


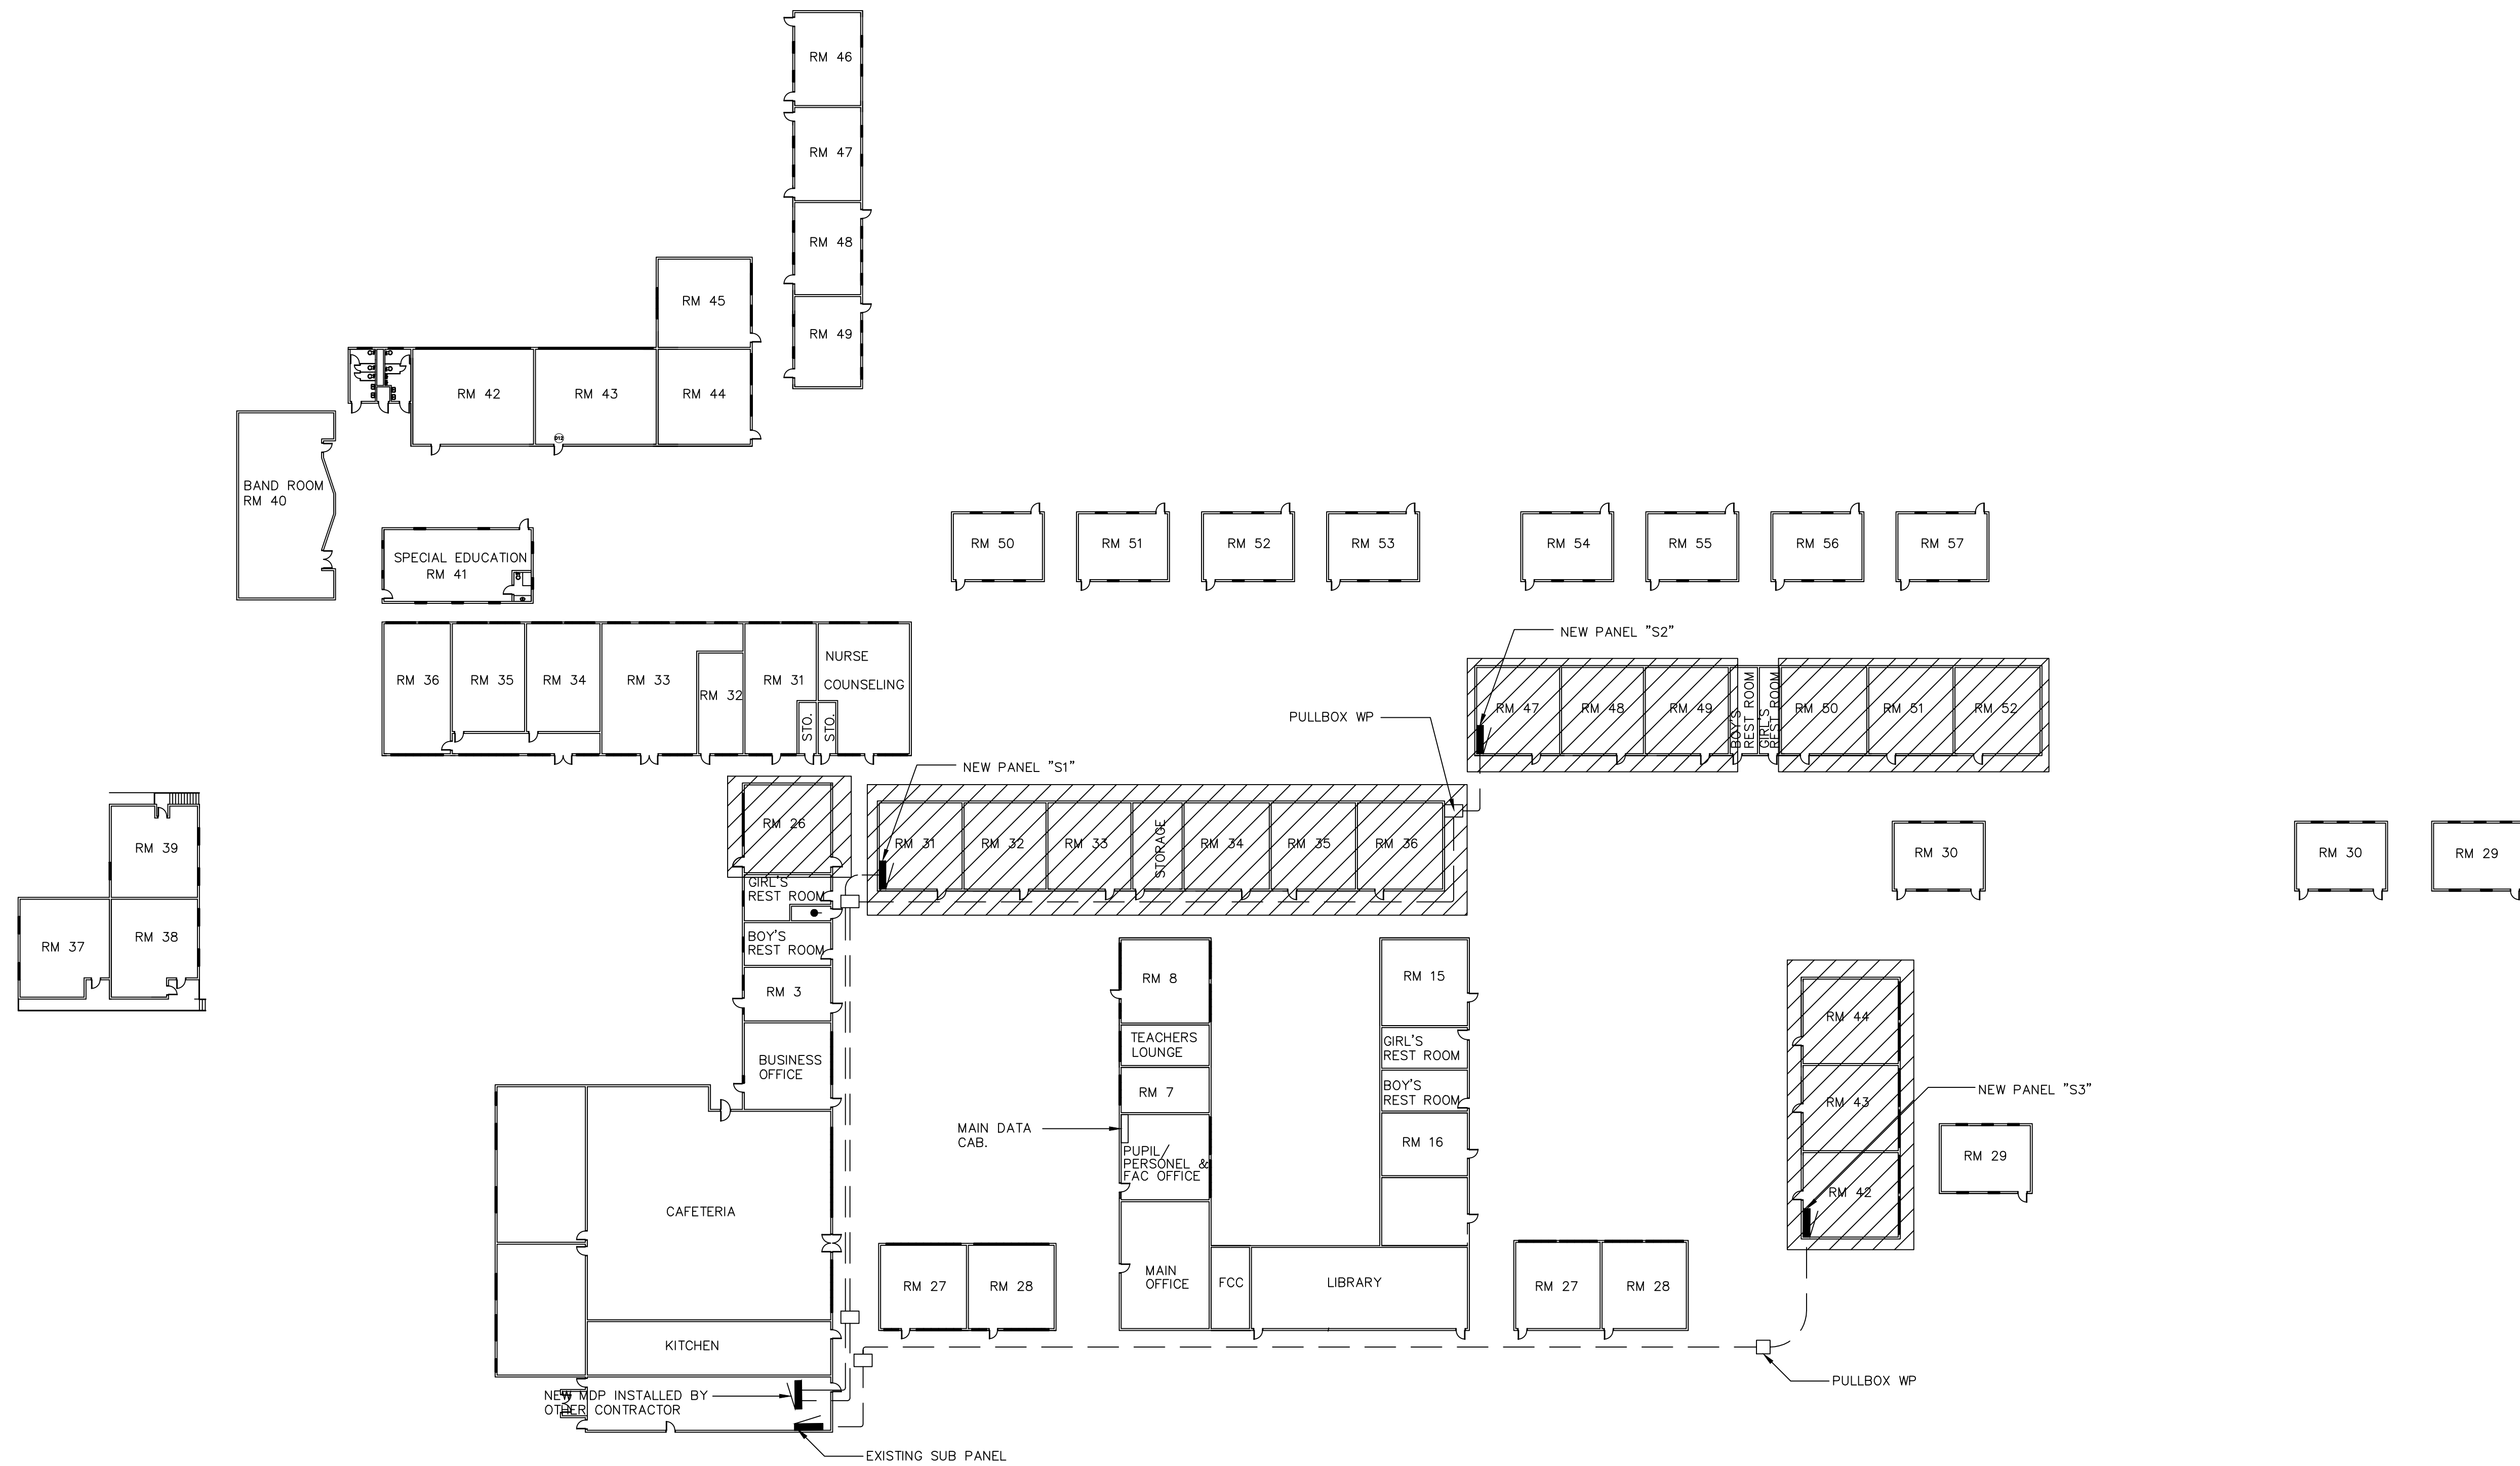

1
E-2 ELECTRICAL SITE PLAN
SCALE: 1" = 400' (APPROX)



AS-BUILT

DATE: _____

SIGNED: _____

SHEET TITLE:
ELECTRICAL SITE PLAN

PROJECT TITLE:
STEM CLASSROOM RENOVATION
LUIS P. UNTALAN MIDDLE SCHOOL
Guam Department of Education
HAGATNA GUAM

REVISION	DESCRIPTION	DATE

DESIGNED BY: _____
DRAWN BY: _____
CHECKED BY: _____
ACAD FILE NO: _____
DATE: _____

SHEET NO:

E-2

— OF —



AS-BUILT

DATE: _____
SIGNED: _____

RM 26 PARTIAL
POWER/SIGNAL PLAN -
NEW CONDITION

STEM CLASSROOM RENOVATION
LUIS P. UNTALAN MIDDLE SCHOOL

Guam Department of Education
HAGATNA GUAM


REVISION	DESCRIPTION	DATE

DESIGNED BY: _____
DRAWN BY: _____
CHECKED BY: _____
ACAD FILE NO: _____
DATE: _____


SHEET NO:


E-6.1

— OF —

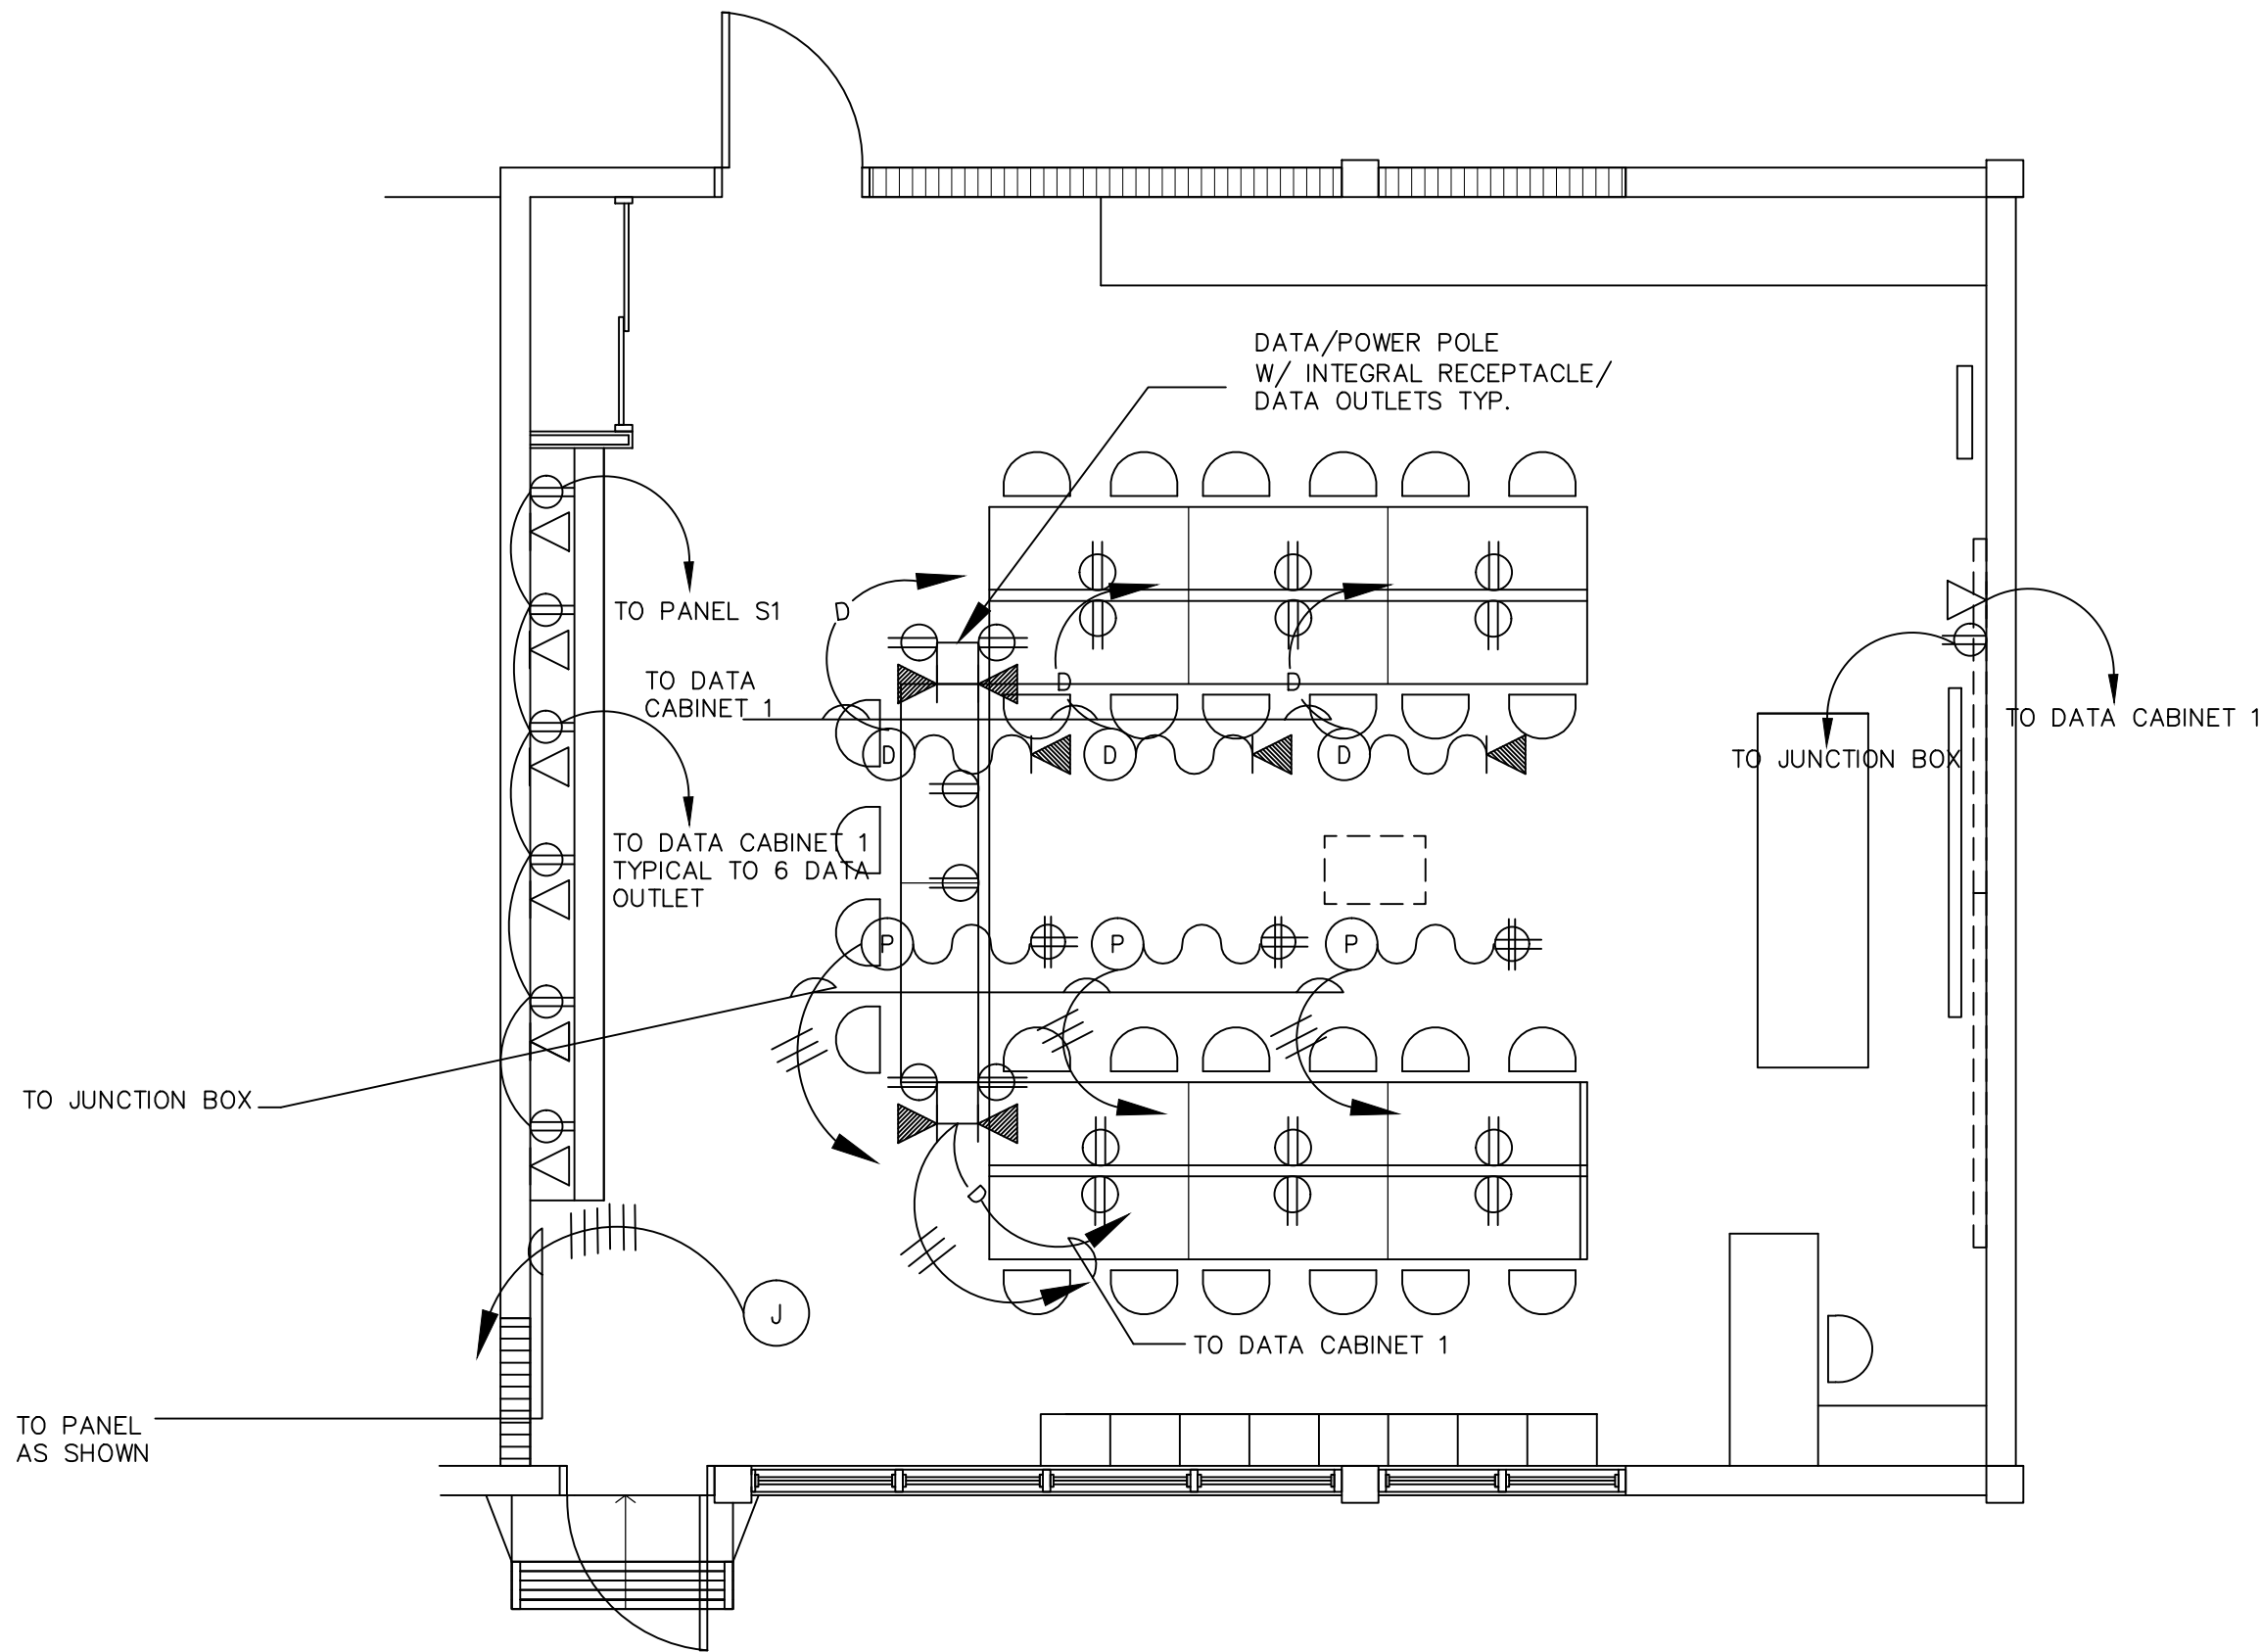

ROOM 26
PARTIAL POWER/SIGNAL PLAN - NEW CONDITION
SCALE: 1/4" = 1'-0"

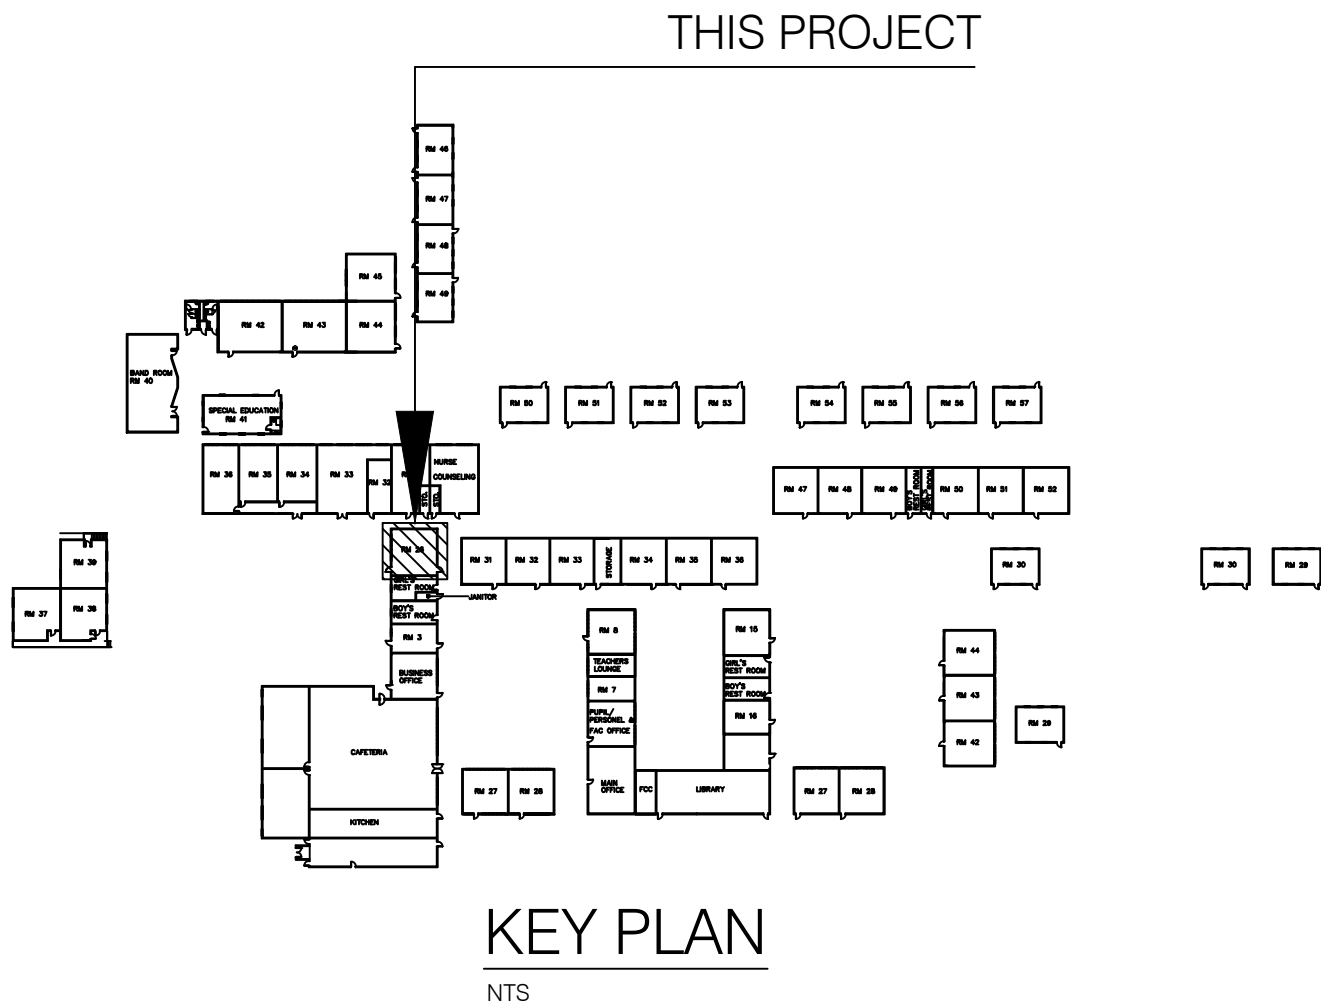


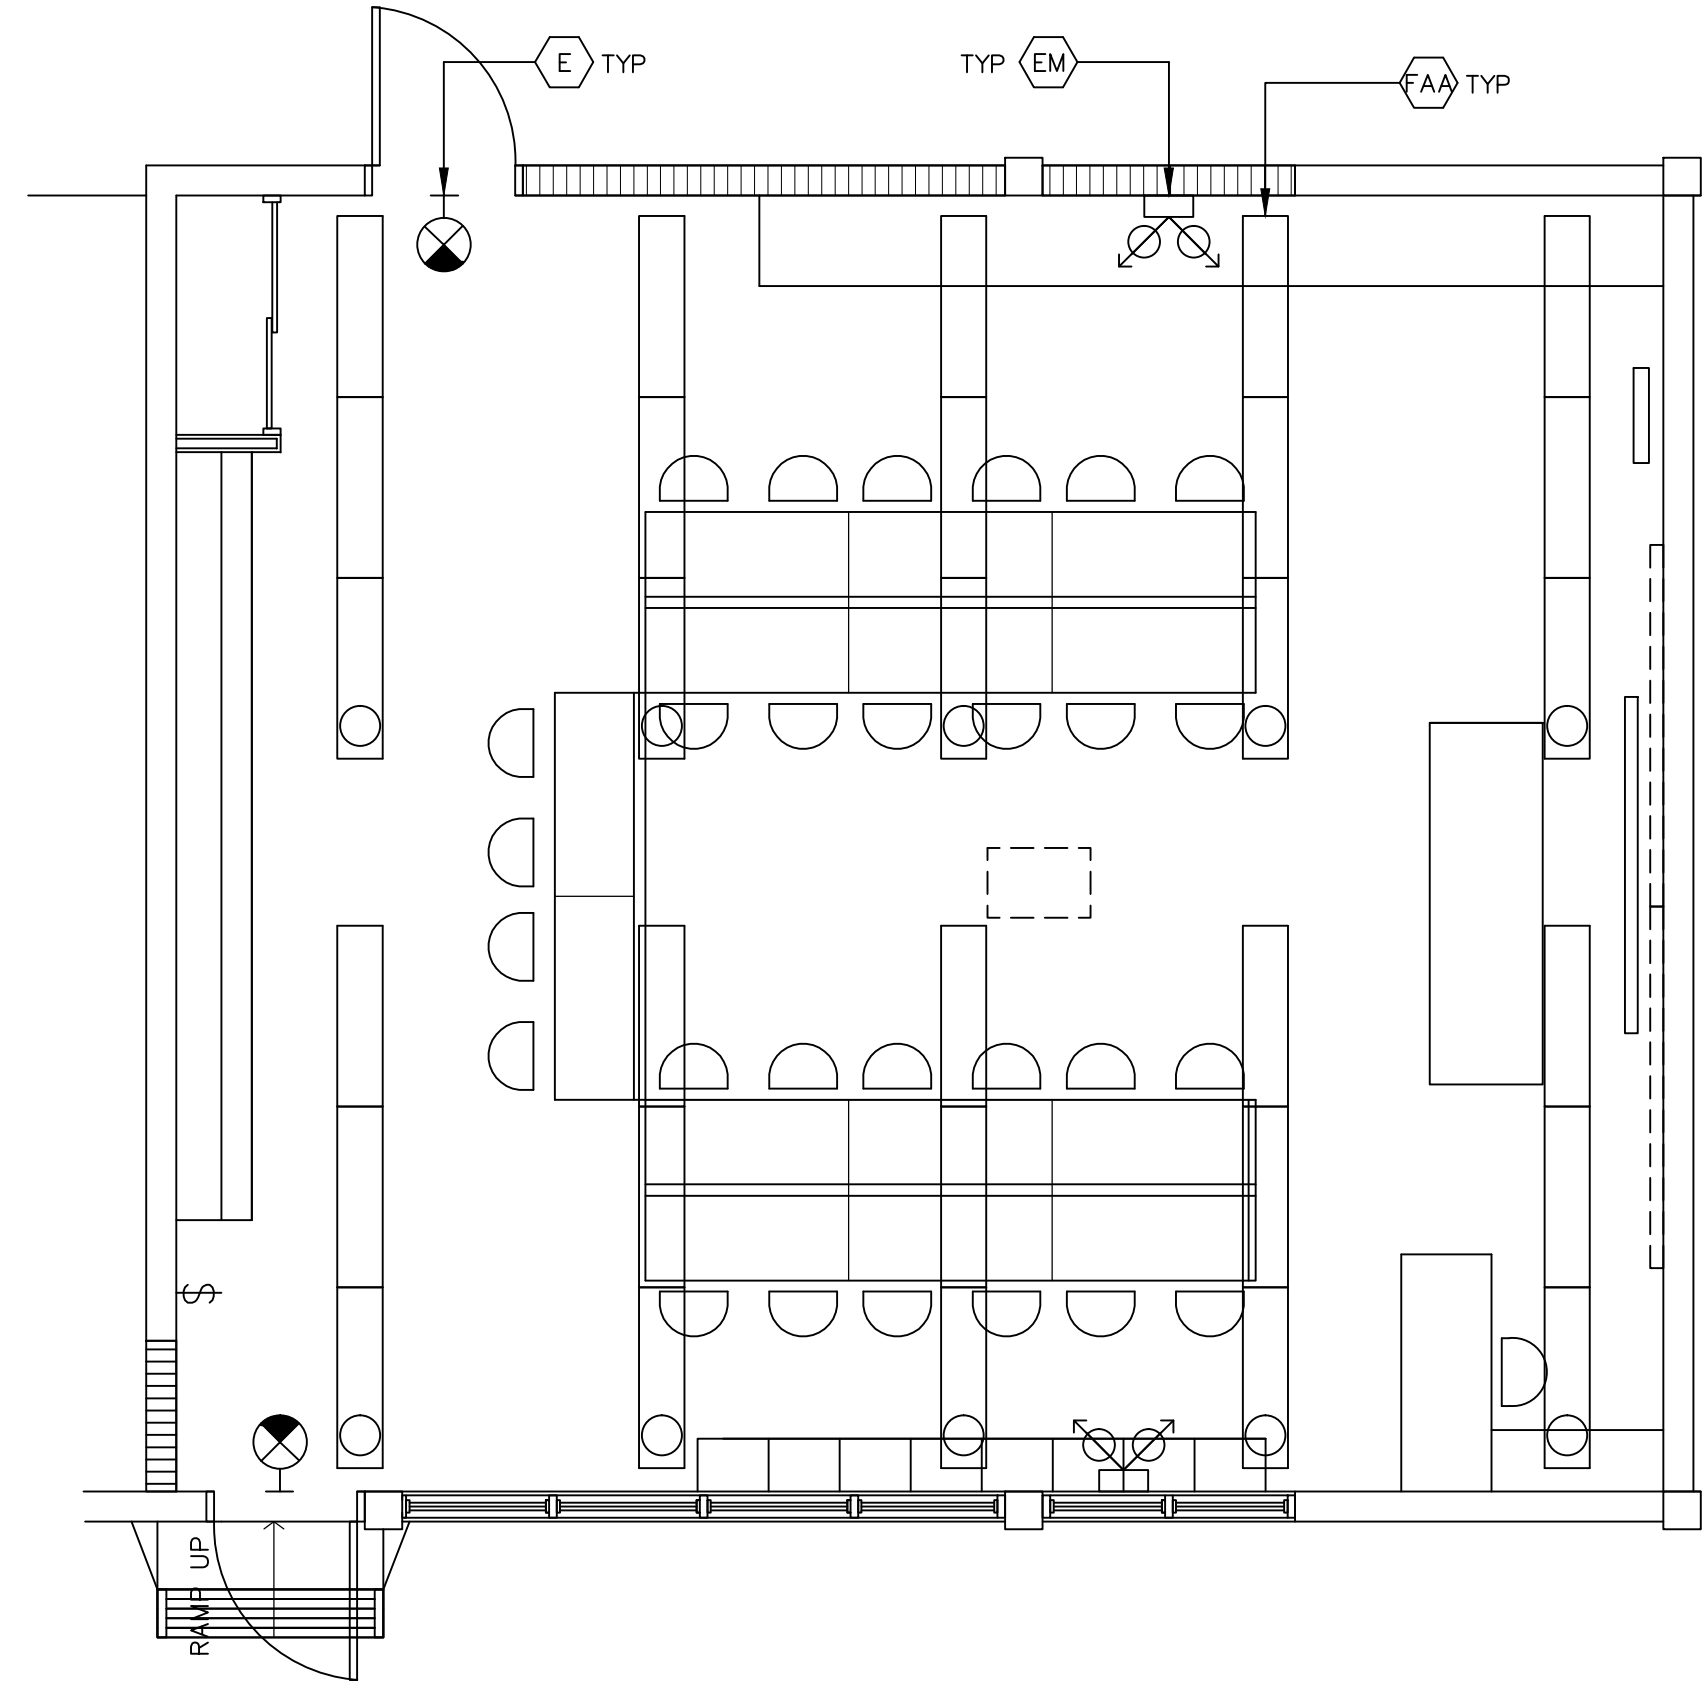

1
E-6.0

ROOM 26 (COMPUTER LAB.)
PARTIAL LIGHTING PLAN - NEW CONDITION


SCALE: 1/4" = 1'-0"

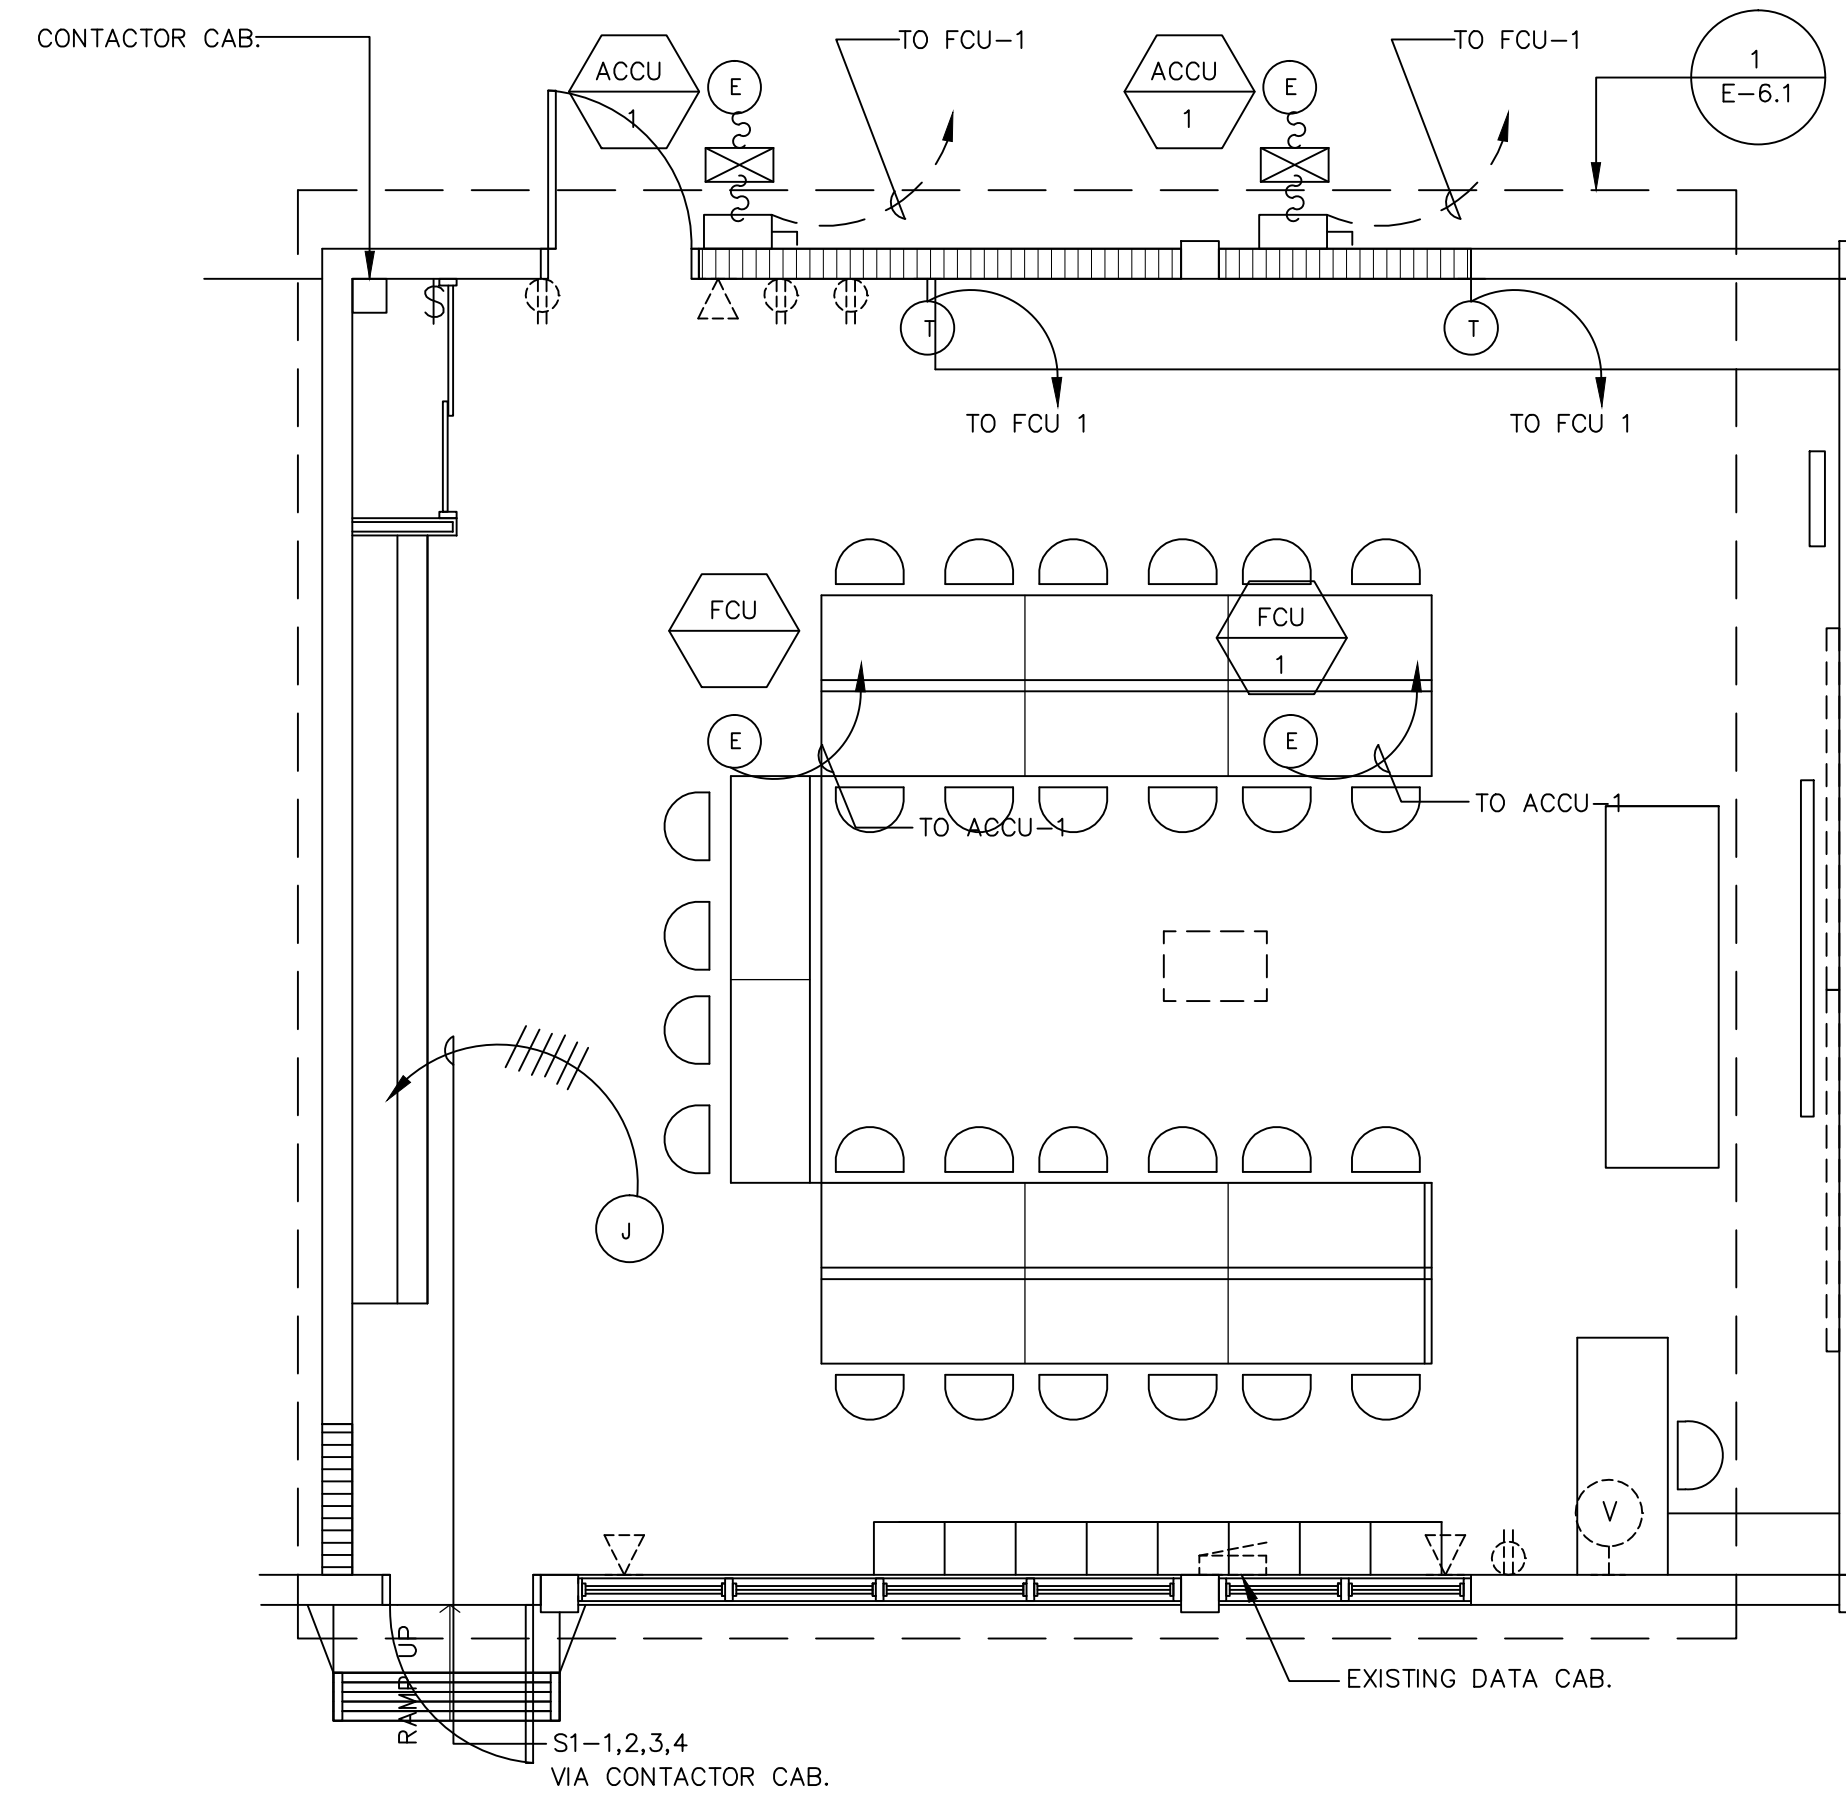

2
E-6.0

ROOM 26 (COMPUTER LAB.)
PARTIAL POWER/SIGNAL PLAN - NEW CONDITION

SCALE: 1/4" = 1'-0"

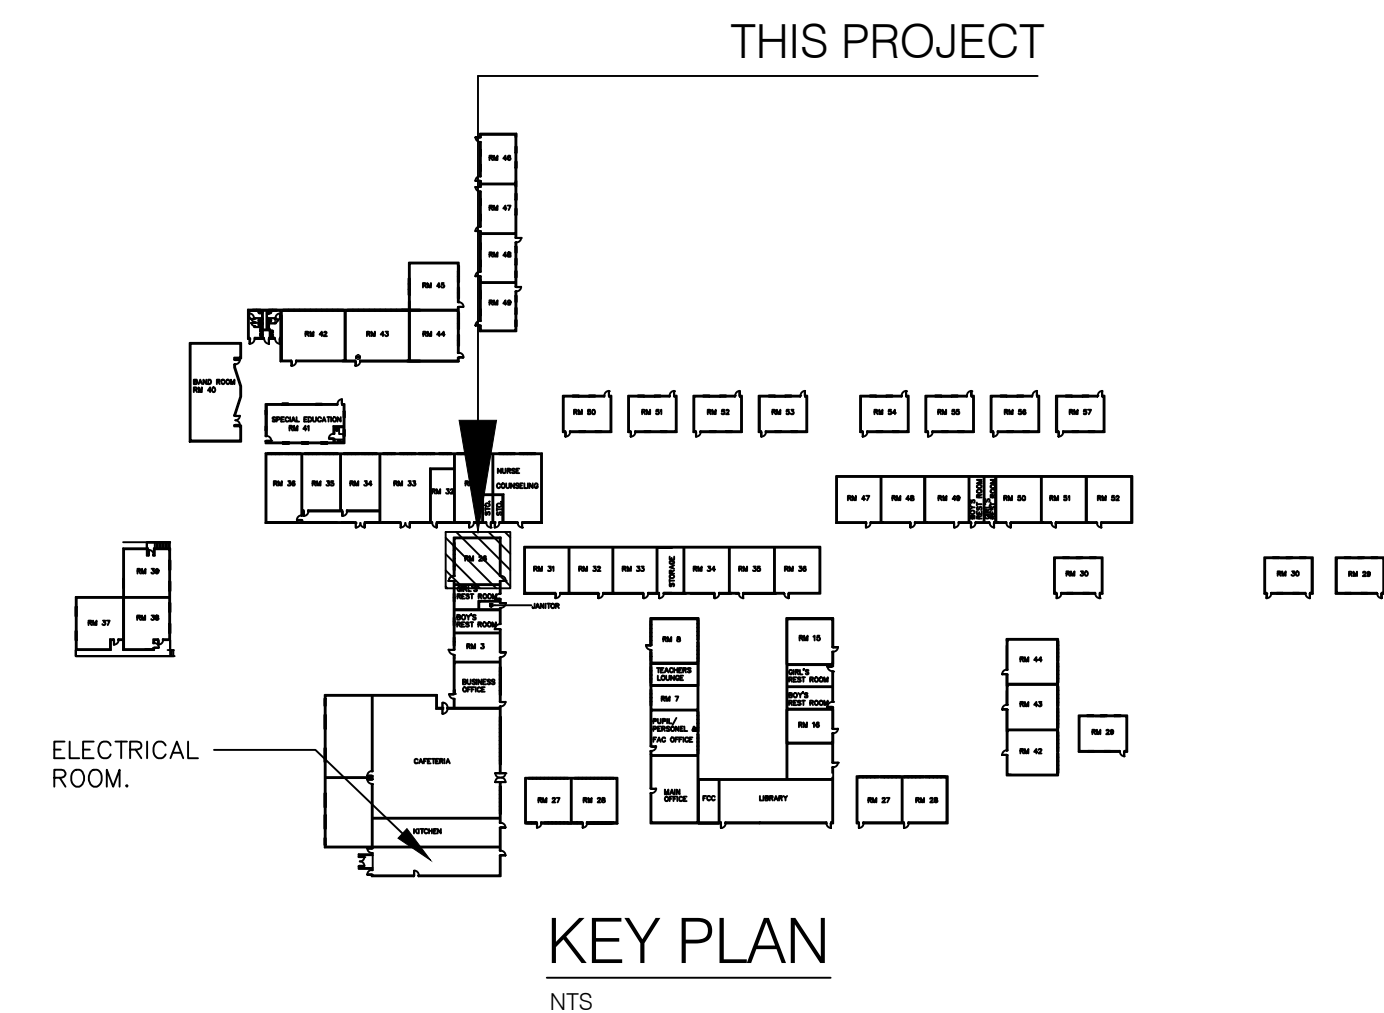

AS-BUILT

DATE:

SIGNED:

SHEET TITLE:

RM 26 (COMPUTER LAB)
PARTIAL LIGHTING PLAN &
POWER/SIGNAL PLAN -
NEW CONDITION

PROJECT TITLE:

STEM CLASSROOM RENOVATION
LUIS P. UNTALAN MIDDLE SCHOOL

Guam Department of Education
HAGATNA GUAM

DATE

DESCRIPTION

REVISION

DESIGNED BY:

DRAWN BY:

CHECKED BY:


ACAD FILE NO:

DATE:

SHEET NO:

E-6.0

— OF —

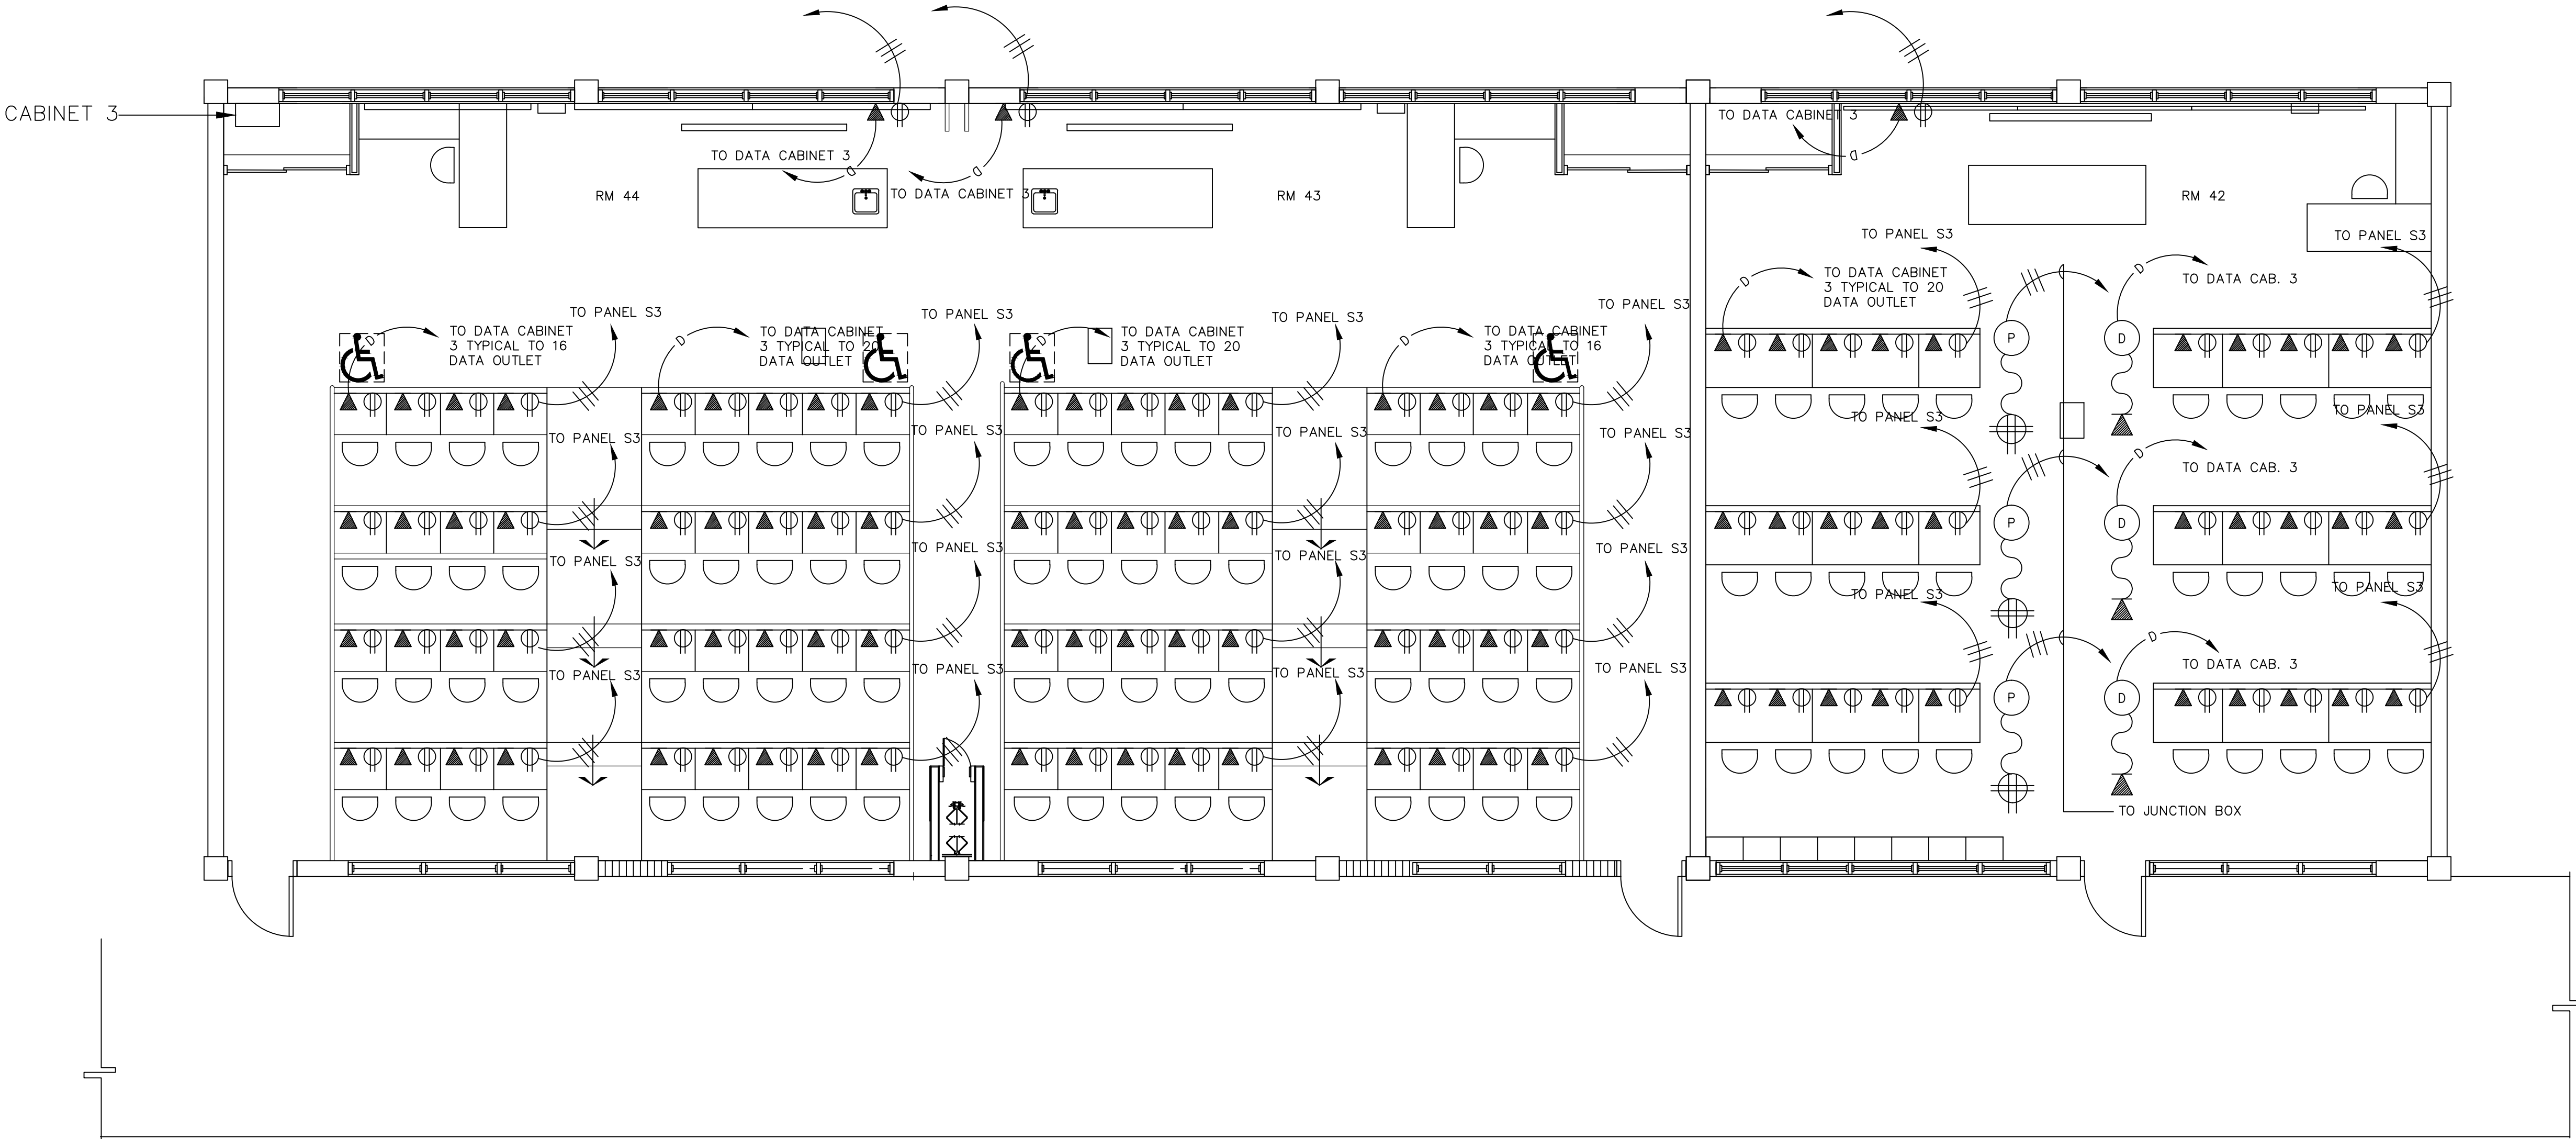

1 ROOMS 44 - 43 (LECTURE ROOM) & 42 (TECHNOLOGY)
E-5.2 POWER/SIGNAL PLAN -NEW CONDITION
SCALE: 1/4" = 1'-0"



AS-BUILT

DATE: _____
SIGNED: _____

SHEET TITLE:

RMS. 44-43 (LECTURE RM),
RM. 42 (TECHNOLOGY)
POWER/SIGNAL PLAN -
NEW CONDITION

PROJECT TITLE:

STEM CLASSROOM RENOVATION
LUIS P. UNTALAN MIDDLE SCHOOL

Guam Department of Education
HAGATNA GUAM

DATE

DESCRIPTION

REVISION

DESIGNED BY:

DRAWN BY:

CHECKED BY:

ACAD FILE NO:

DATE:

SHEET NO:

E-5.1

— OF —



AS-BUILT

DATE: _____

SIGNED: _____

SHEET TITLE:
RMS. 44-43 (LECTURE RM),
RM 42 (TECHNOLOGY)
LIGHTING PLAN &
POWER/SIGNAL PLAN -
NEW CONDITION

PROJECT TITLE:
STEM CLASSROOM RENOVATION
LUIS P. UNTALAN MIDDLE SCHOOL

Gum Department of Education
HAGATNA GUAM


REVISION	DESCRIPTION	DATE

DESIGNED BY: _____
DRAWN BY: _____
CHECKED BY: _____
ACAD FILE NO: _____
DATE: _____


SHEET NO:

E-5.0


— OF —

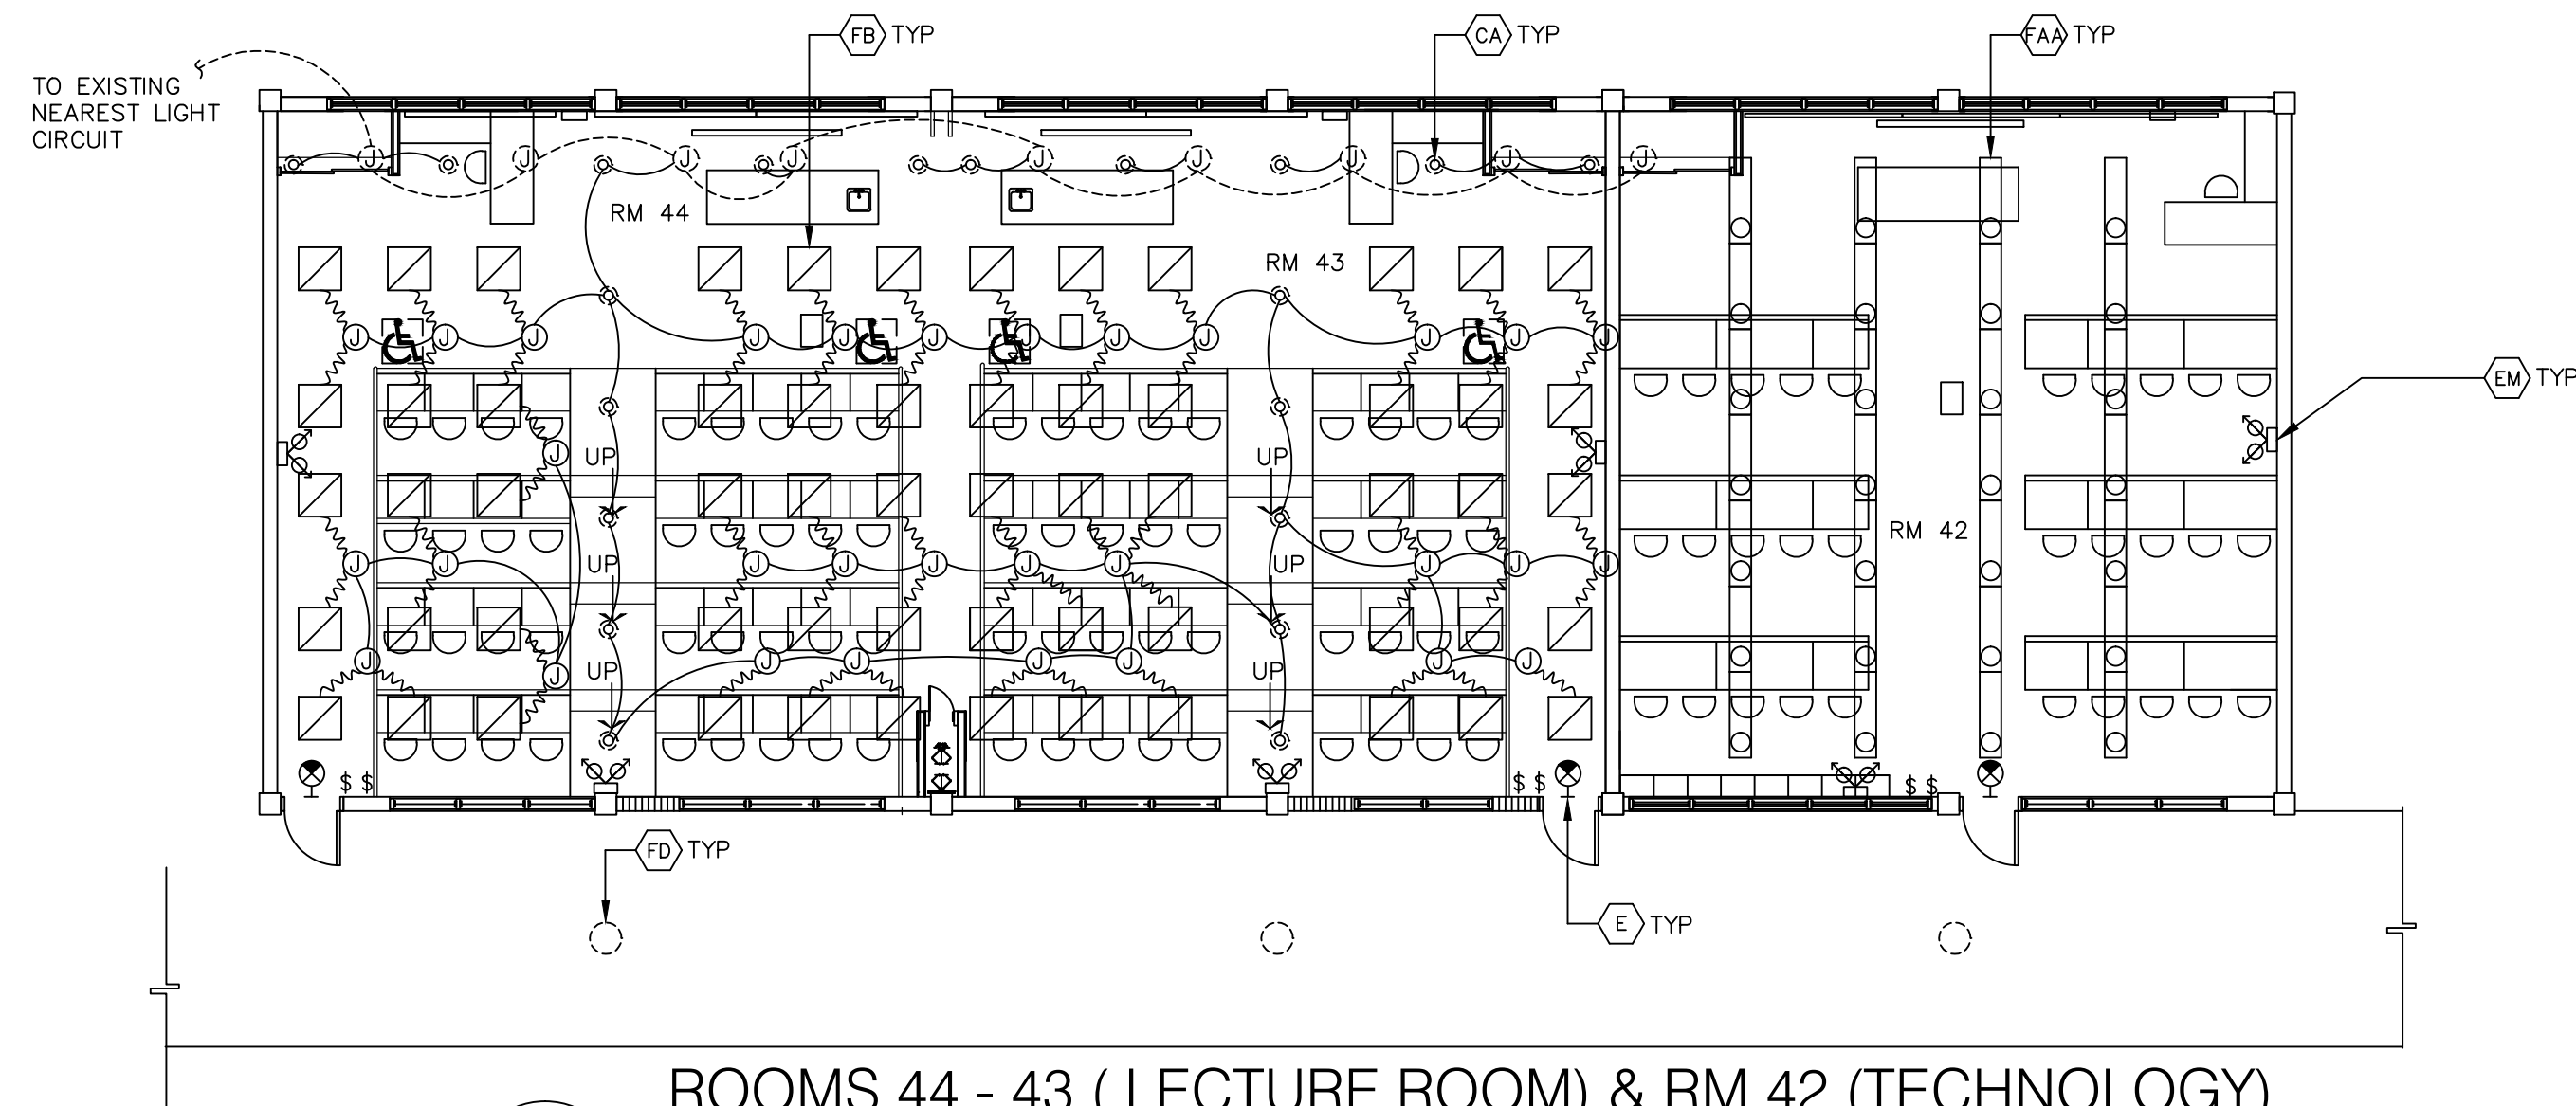

1
E-5.1
ROOMS 44 - 43 (LECTURE ROOM) & RM 42 (TECHNOLOGY)
LIGHTING PLAN - NEW CONDITION
SCALE: 1/8" = 1'-0"

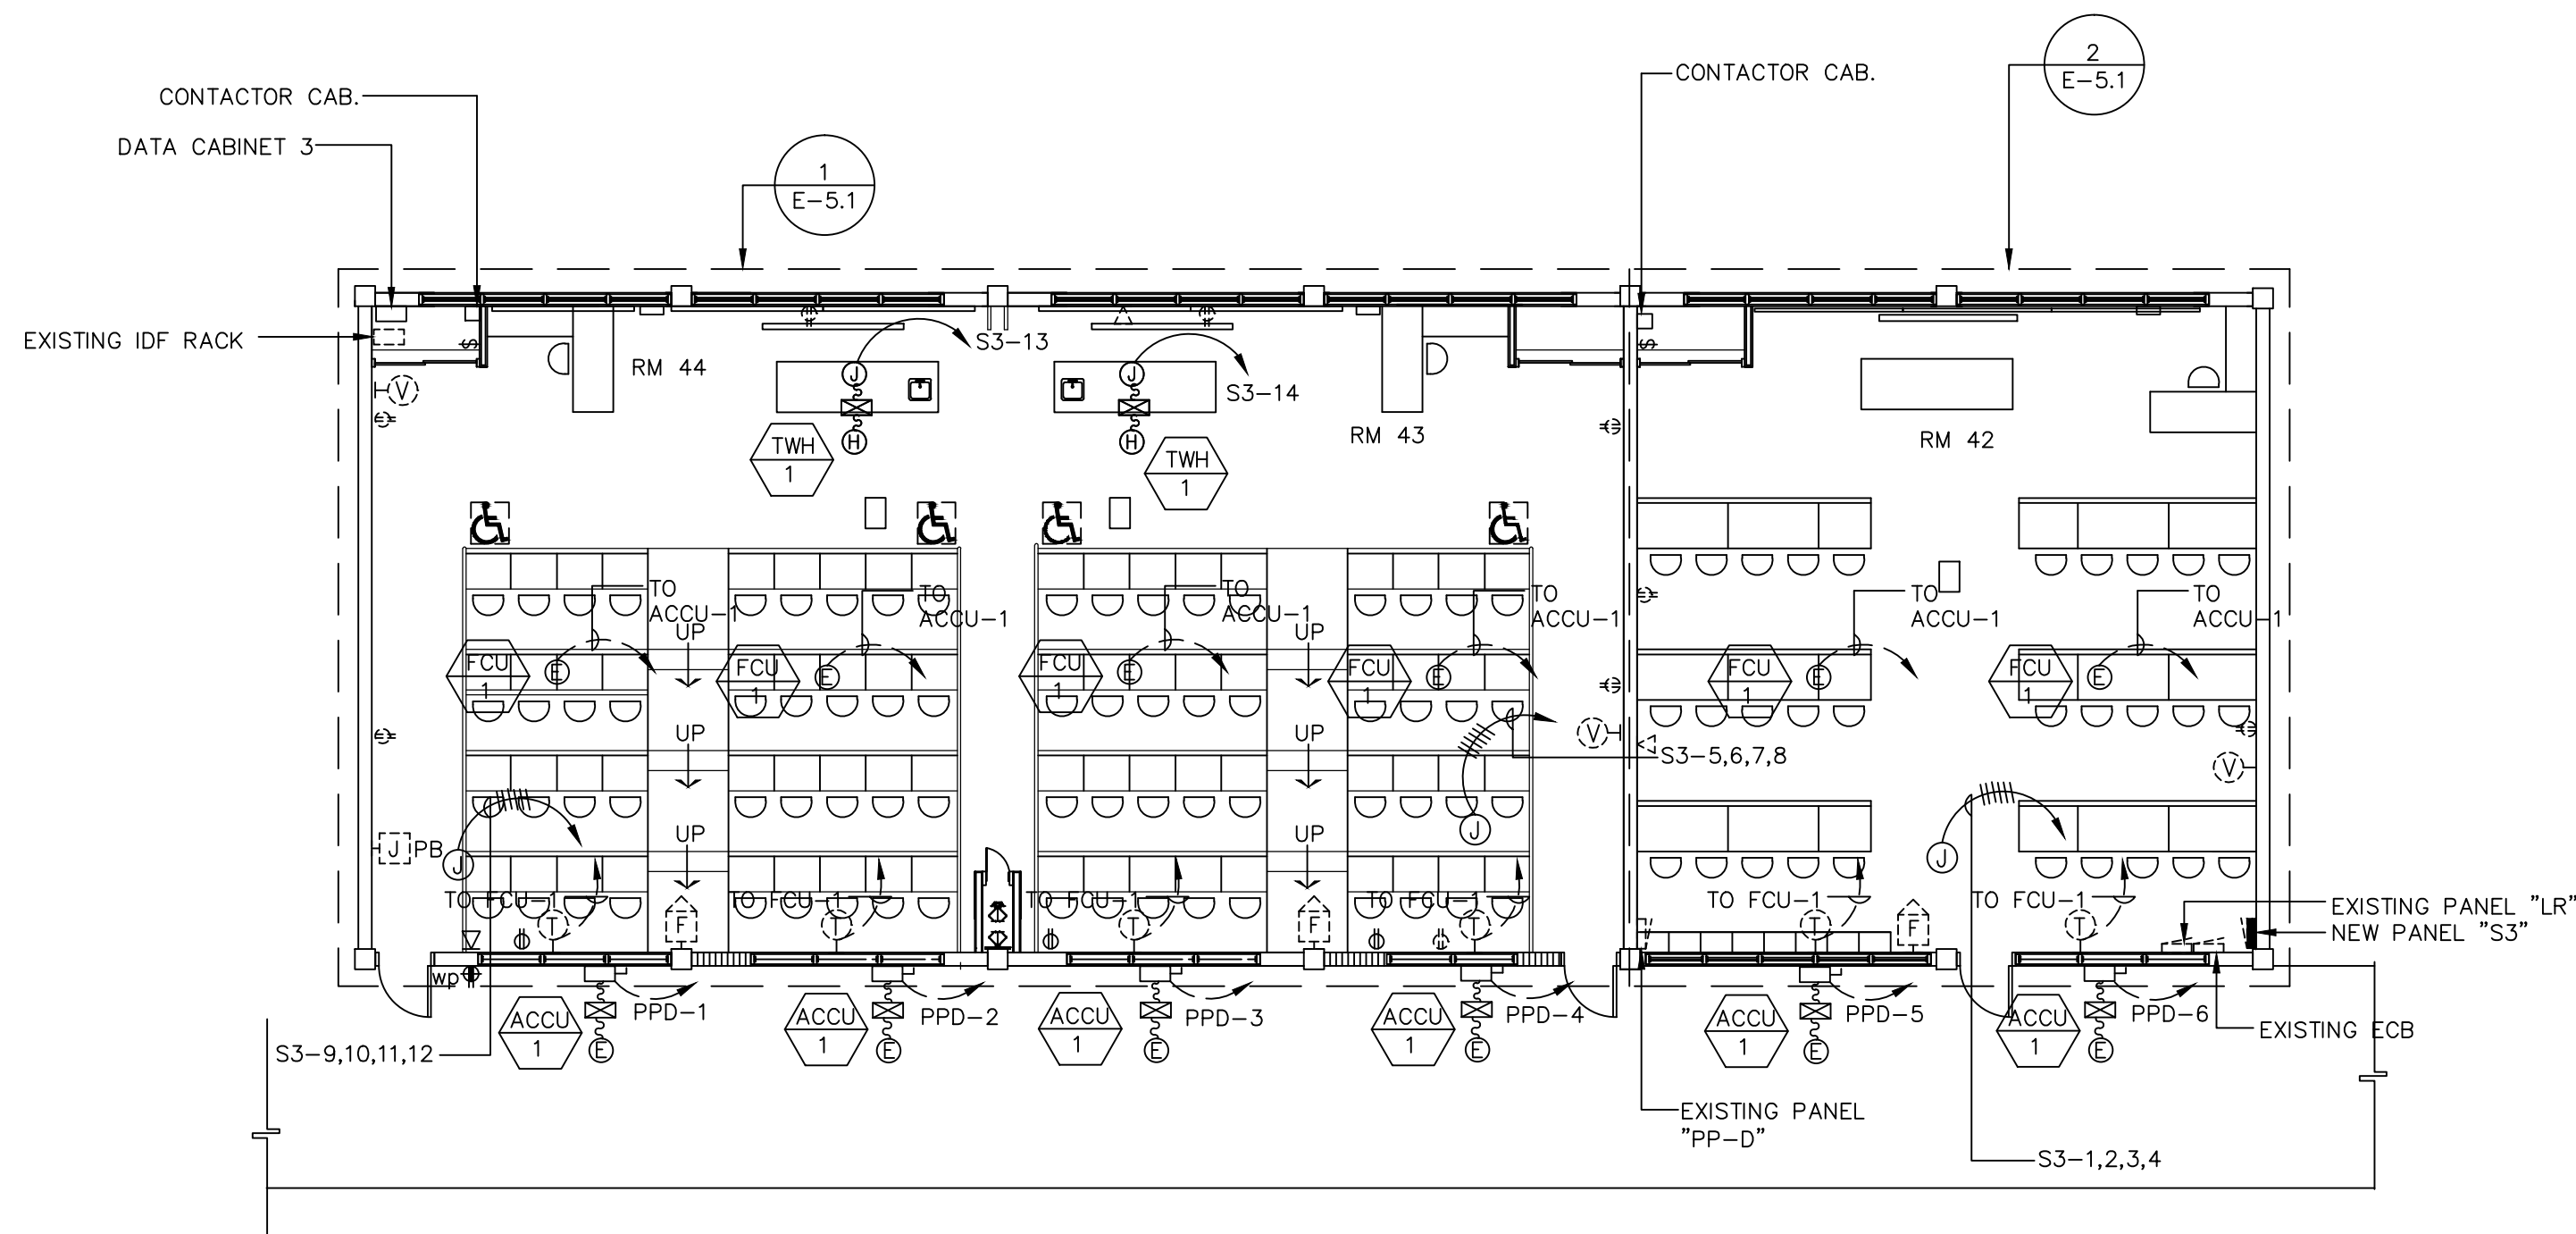

2
E-5.0
ROOMS 44 - 43 (LECTURE ROOM) & RM 42 (TECHNOLOGY)
POWER/SIGNAL PLAN - NEW CONDITION
SCALE: 1/8" = 1'-0"

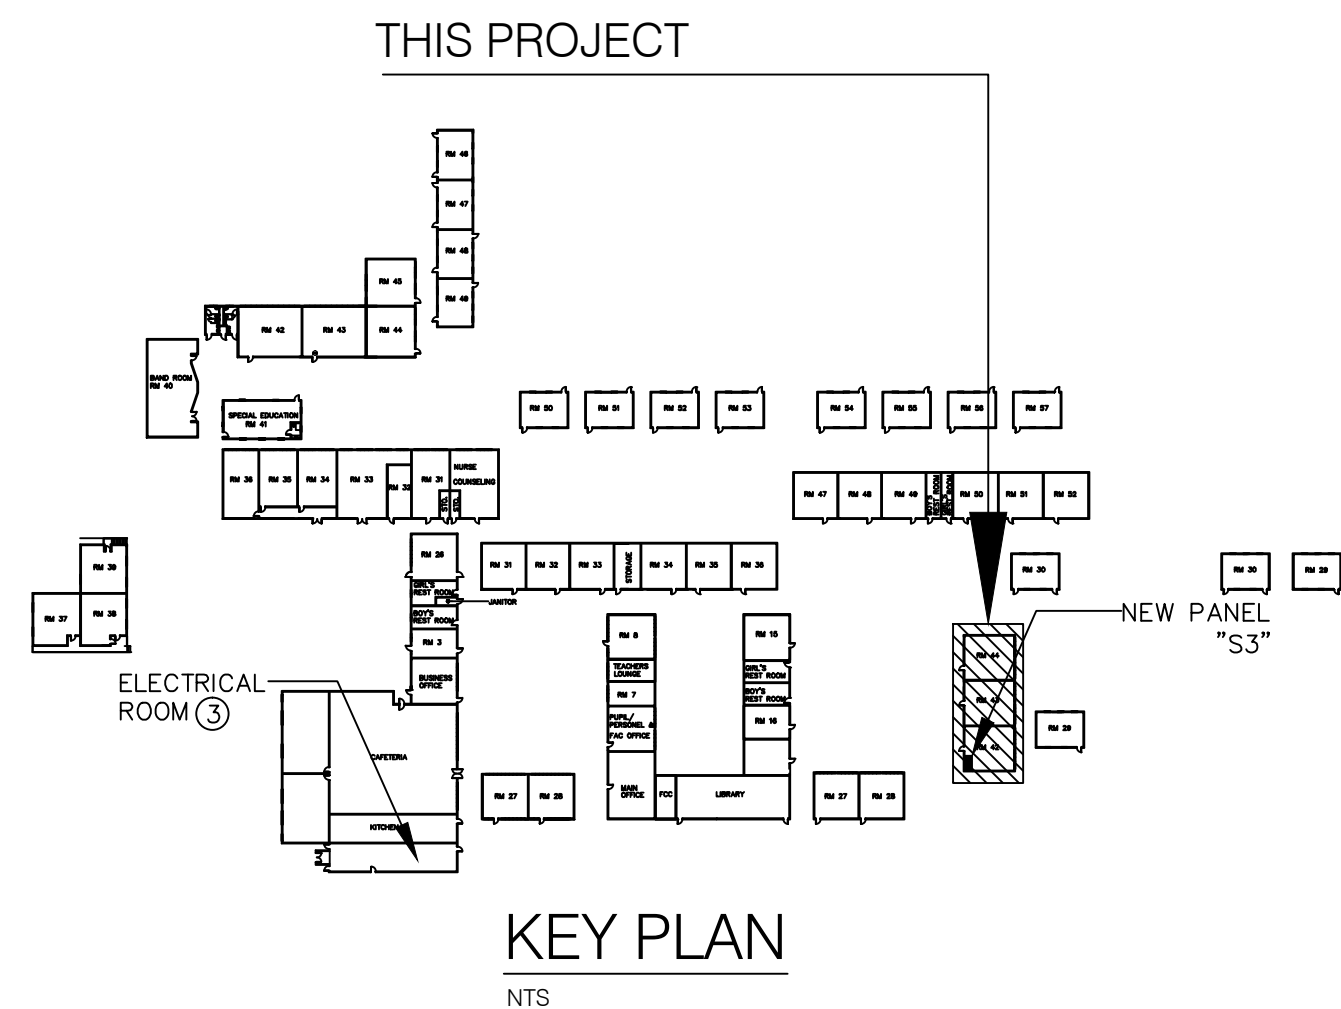



AS-BUILT

DATE: _____

SIGNED: _____

SHEET TITLE:

RMS. 35-36 (SCIENCE)
TYP. CLASSROOM
POWER/SIGNAL PLAN

PROJECT TITLE:

STEM CLASSROOM RENOVATION
LUIS P. UNTALAN MIDDLE SCHOOL

Guam Department of Education
HAGATNA GUAM

DATE

DESCRIPTION

REVISION

DESIGNED BY:

DRAWN BY:

CHECKED BY:


ACAD FILE NO:

DATE:

SHEET NO:

E-4.3

— OF —

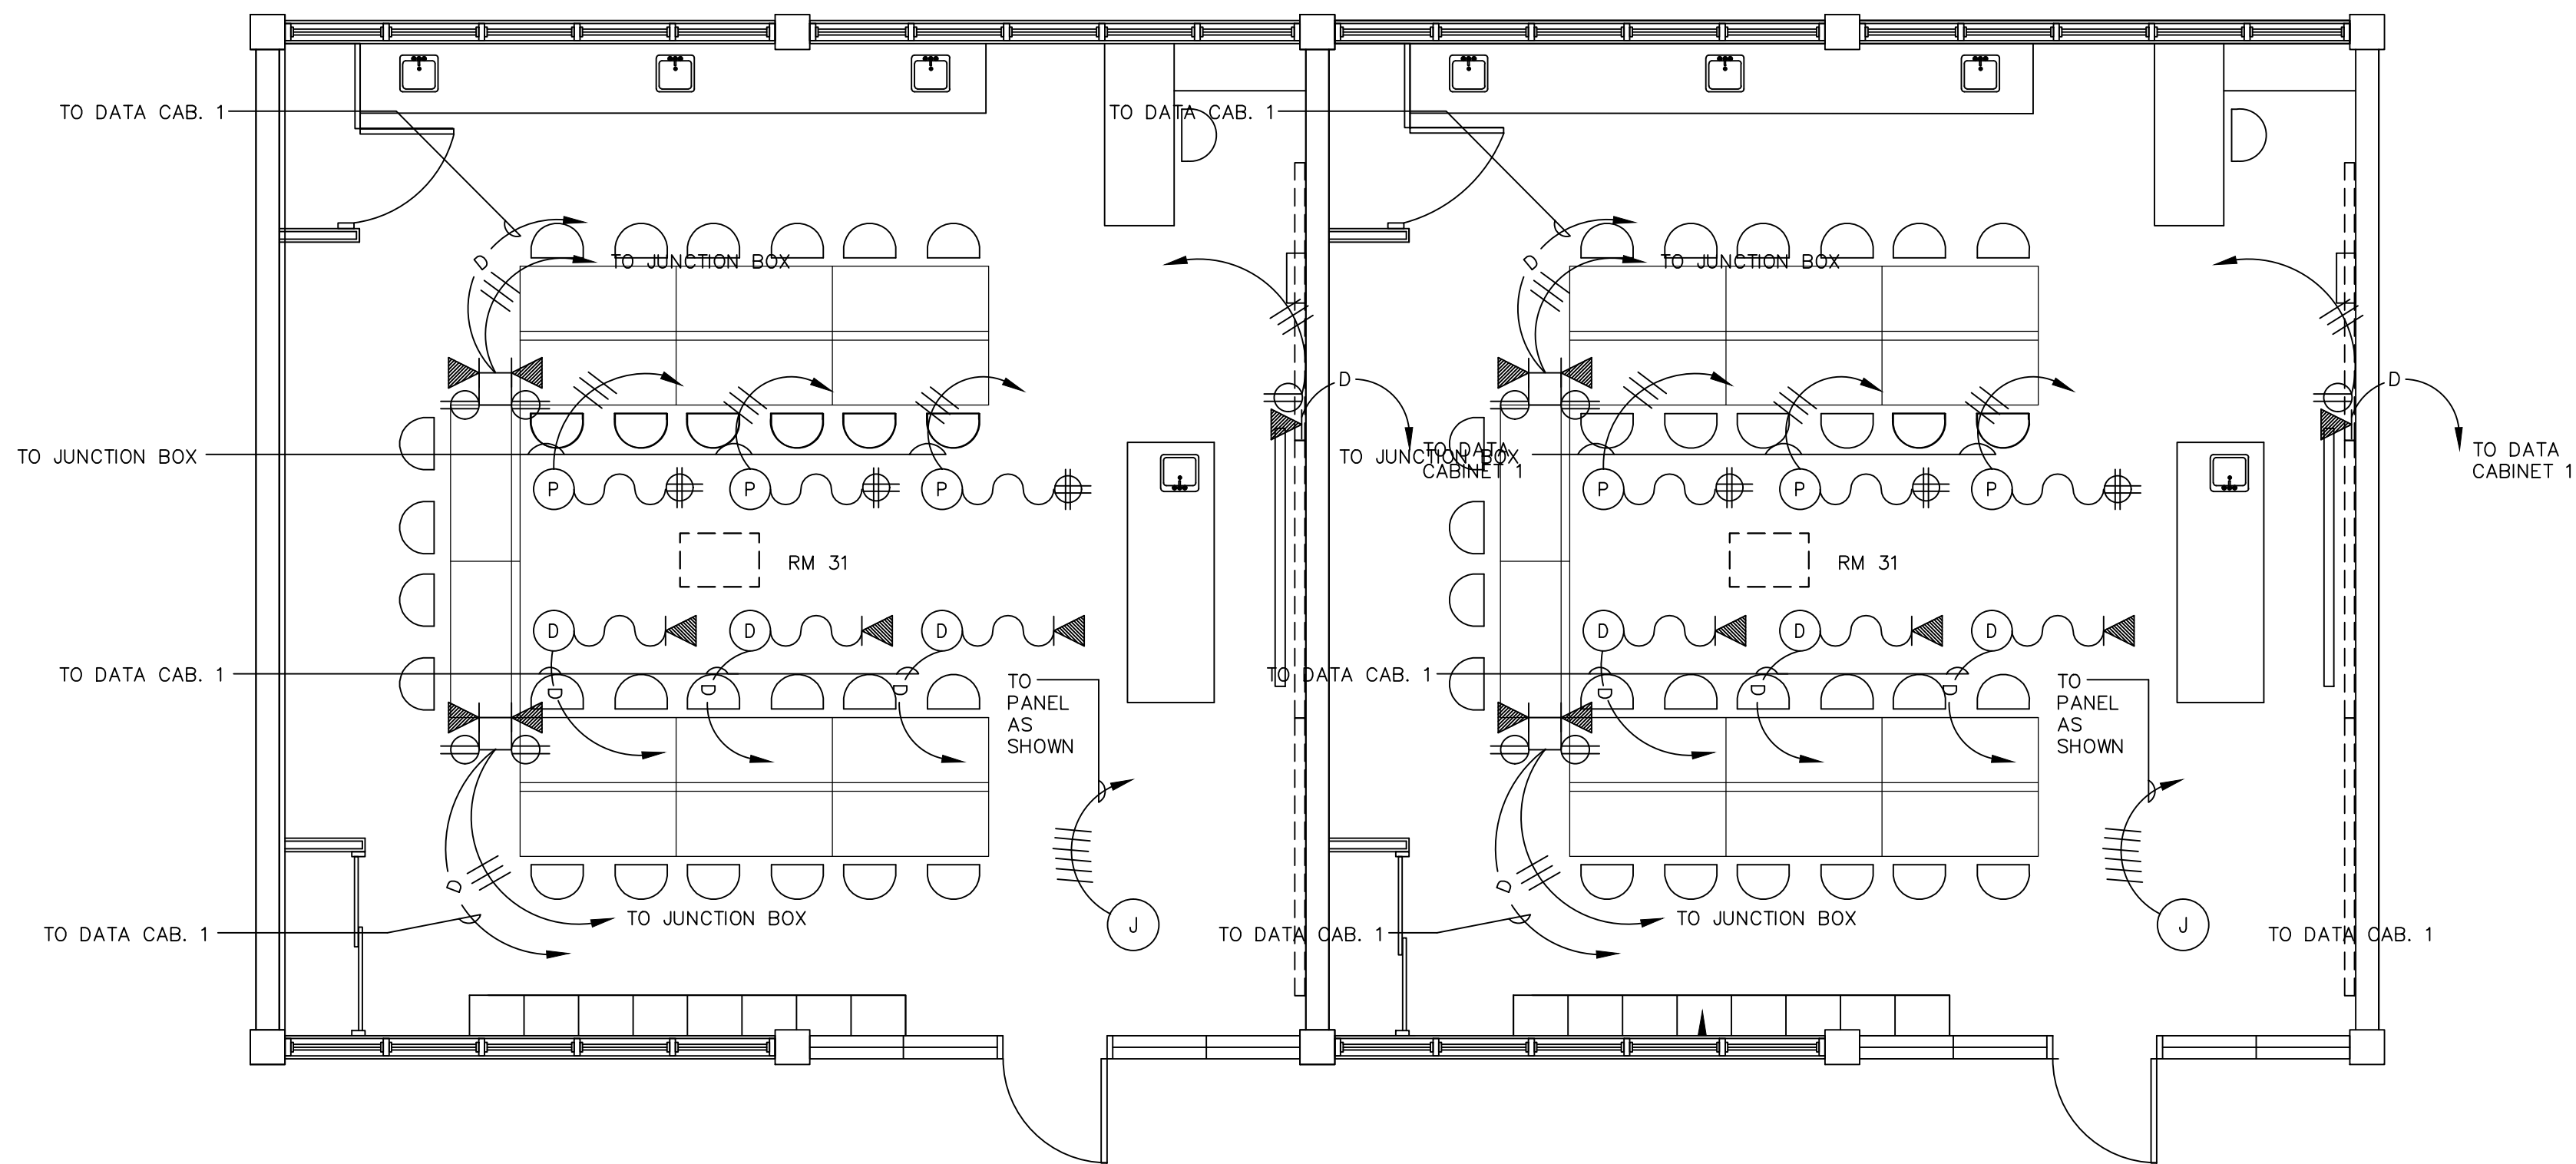

1
E-4.4

ROOM 35 TO 36 (SCIENCE)
TYPICAL CLASSROOM POWER/SIGNAL PLAN

SCALE: 1/4" = 1'-0"



AS-BUILT

DATE: _____
SIGNED: _____

RMS. 33-34 (SCIENCE)
TYP. CLASSROOM
POWER/SIGNAL PLAN

SHEET TITLE:

PROJECT TITLE:

STEM CLASSROOM RENOVATION
LUIS P. UNTALAN MIDDLE SCHOOL

Guam Department of Education
HAGATNA GUAM


REVISION	DESCRIPTION	DATE

DESIGNED BY: _____
DRAWN BY: _____
CHECKED BY: _____
ACAD FILE NO: _____
DATE: _____

SHEET NO:

E-4.2

— OF —

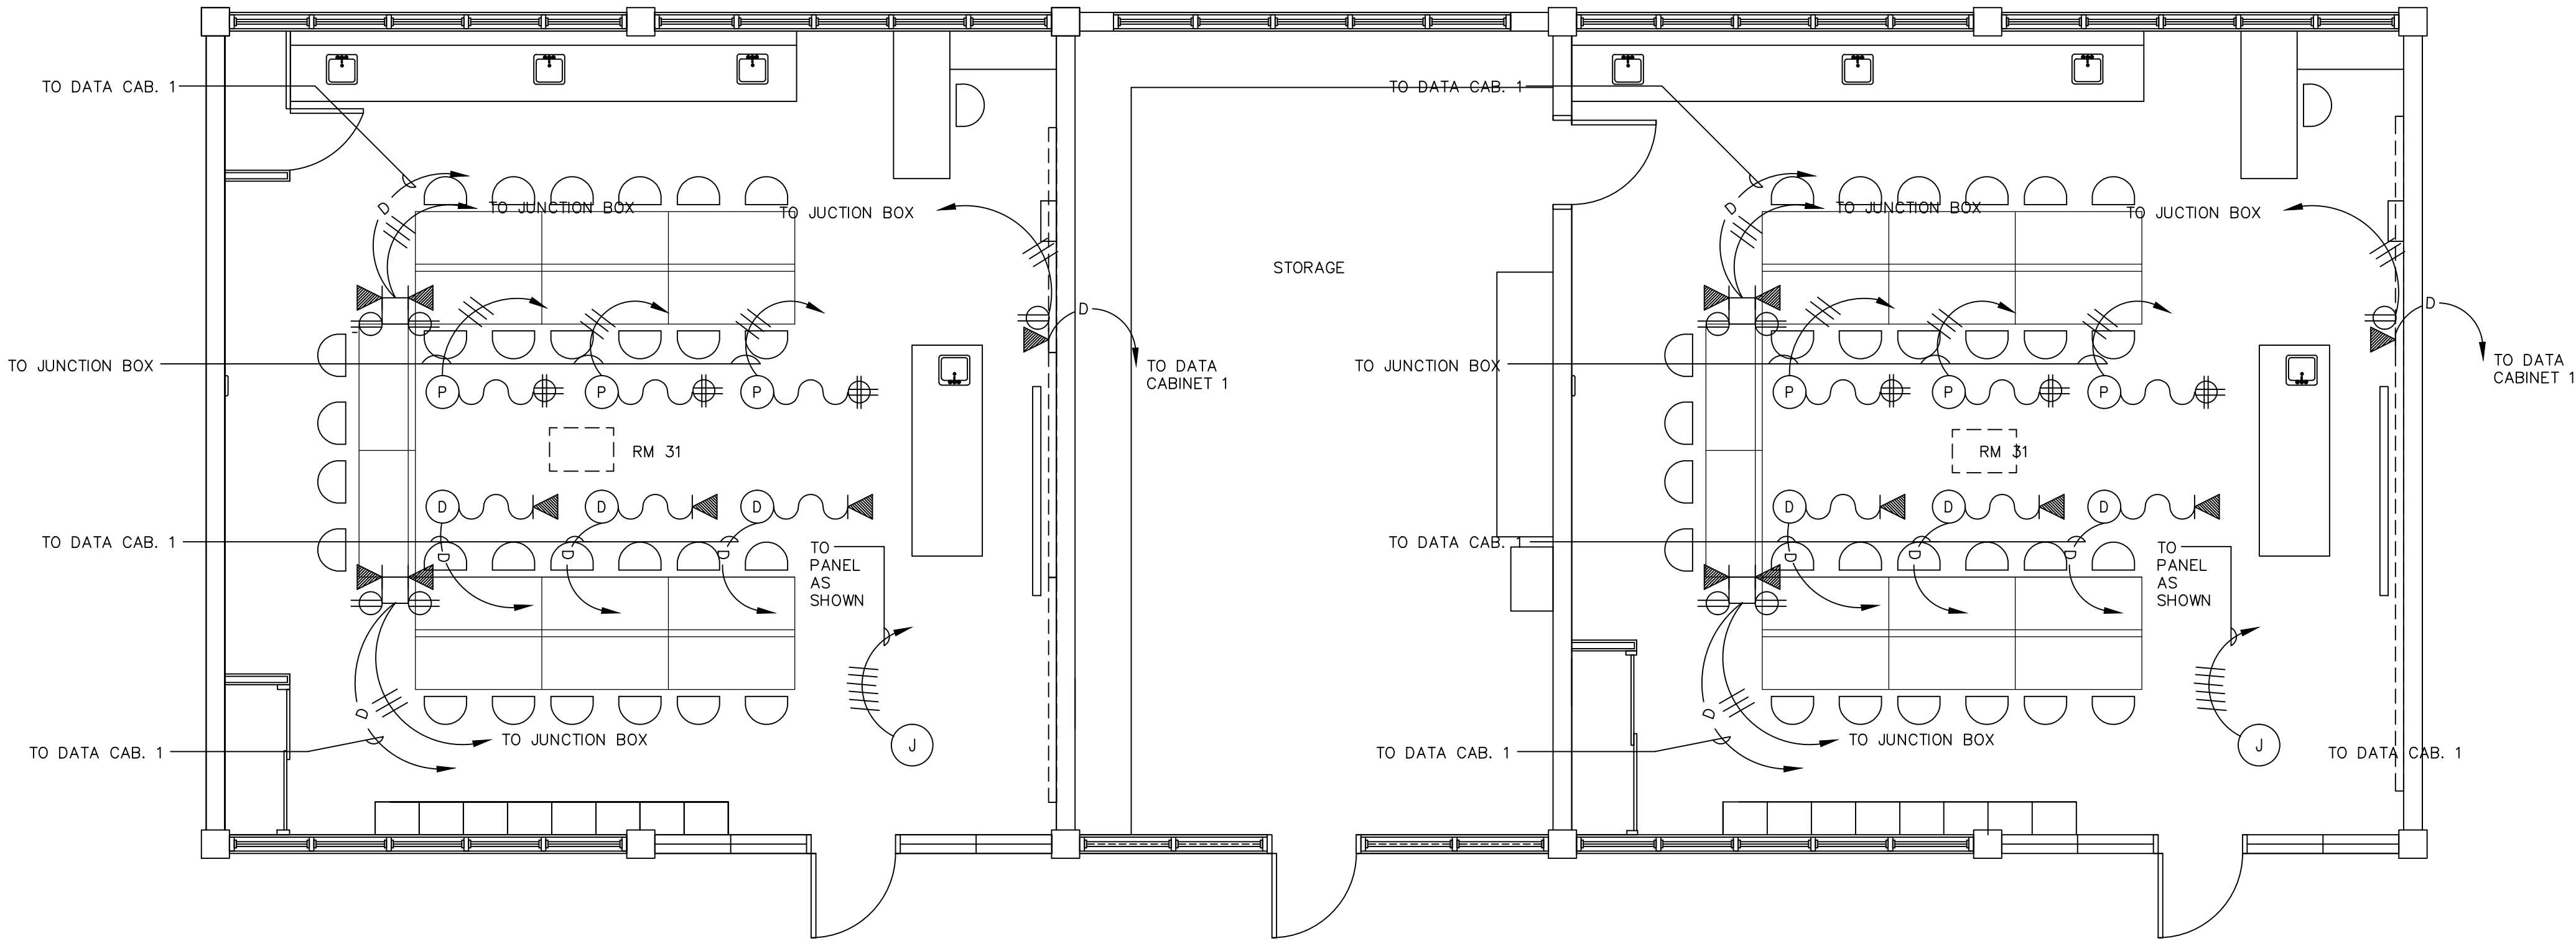

1
E-4.2
ROOM 33 TO 34 (SCIENCE)
TYPICAL CLASSROOM POWER/SIGNAL PLAN
SCALE: 1/4" = 1'-0"



AS-BUILT

DATE: _____
SIGNED: _____

RMS. 31-32 (SCIENCE)
TYP. CLASSROOM
POWER/SIGNAL PLAN

STEM CLASSROOM RENOVATION
LUIS P. UNTALAN MIDDLE SCHOOL

Gum Department of Education
HAGATNA GUAM


REVISION	DESCRIPTION	DATE

DESIGNED BY: _____
DRAWN BY: _____
CHECKED BY: _____
ACAD FILE NO: _____
DATE: _____

SHEET NO:

E-4.1

— OF —

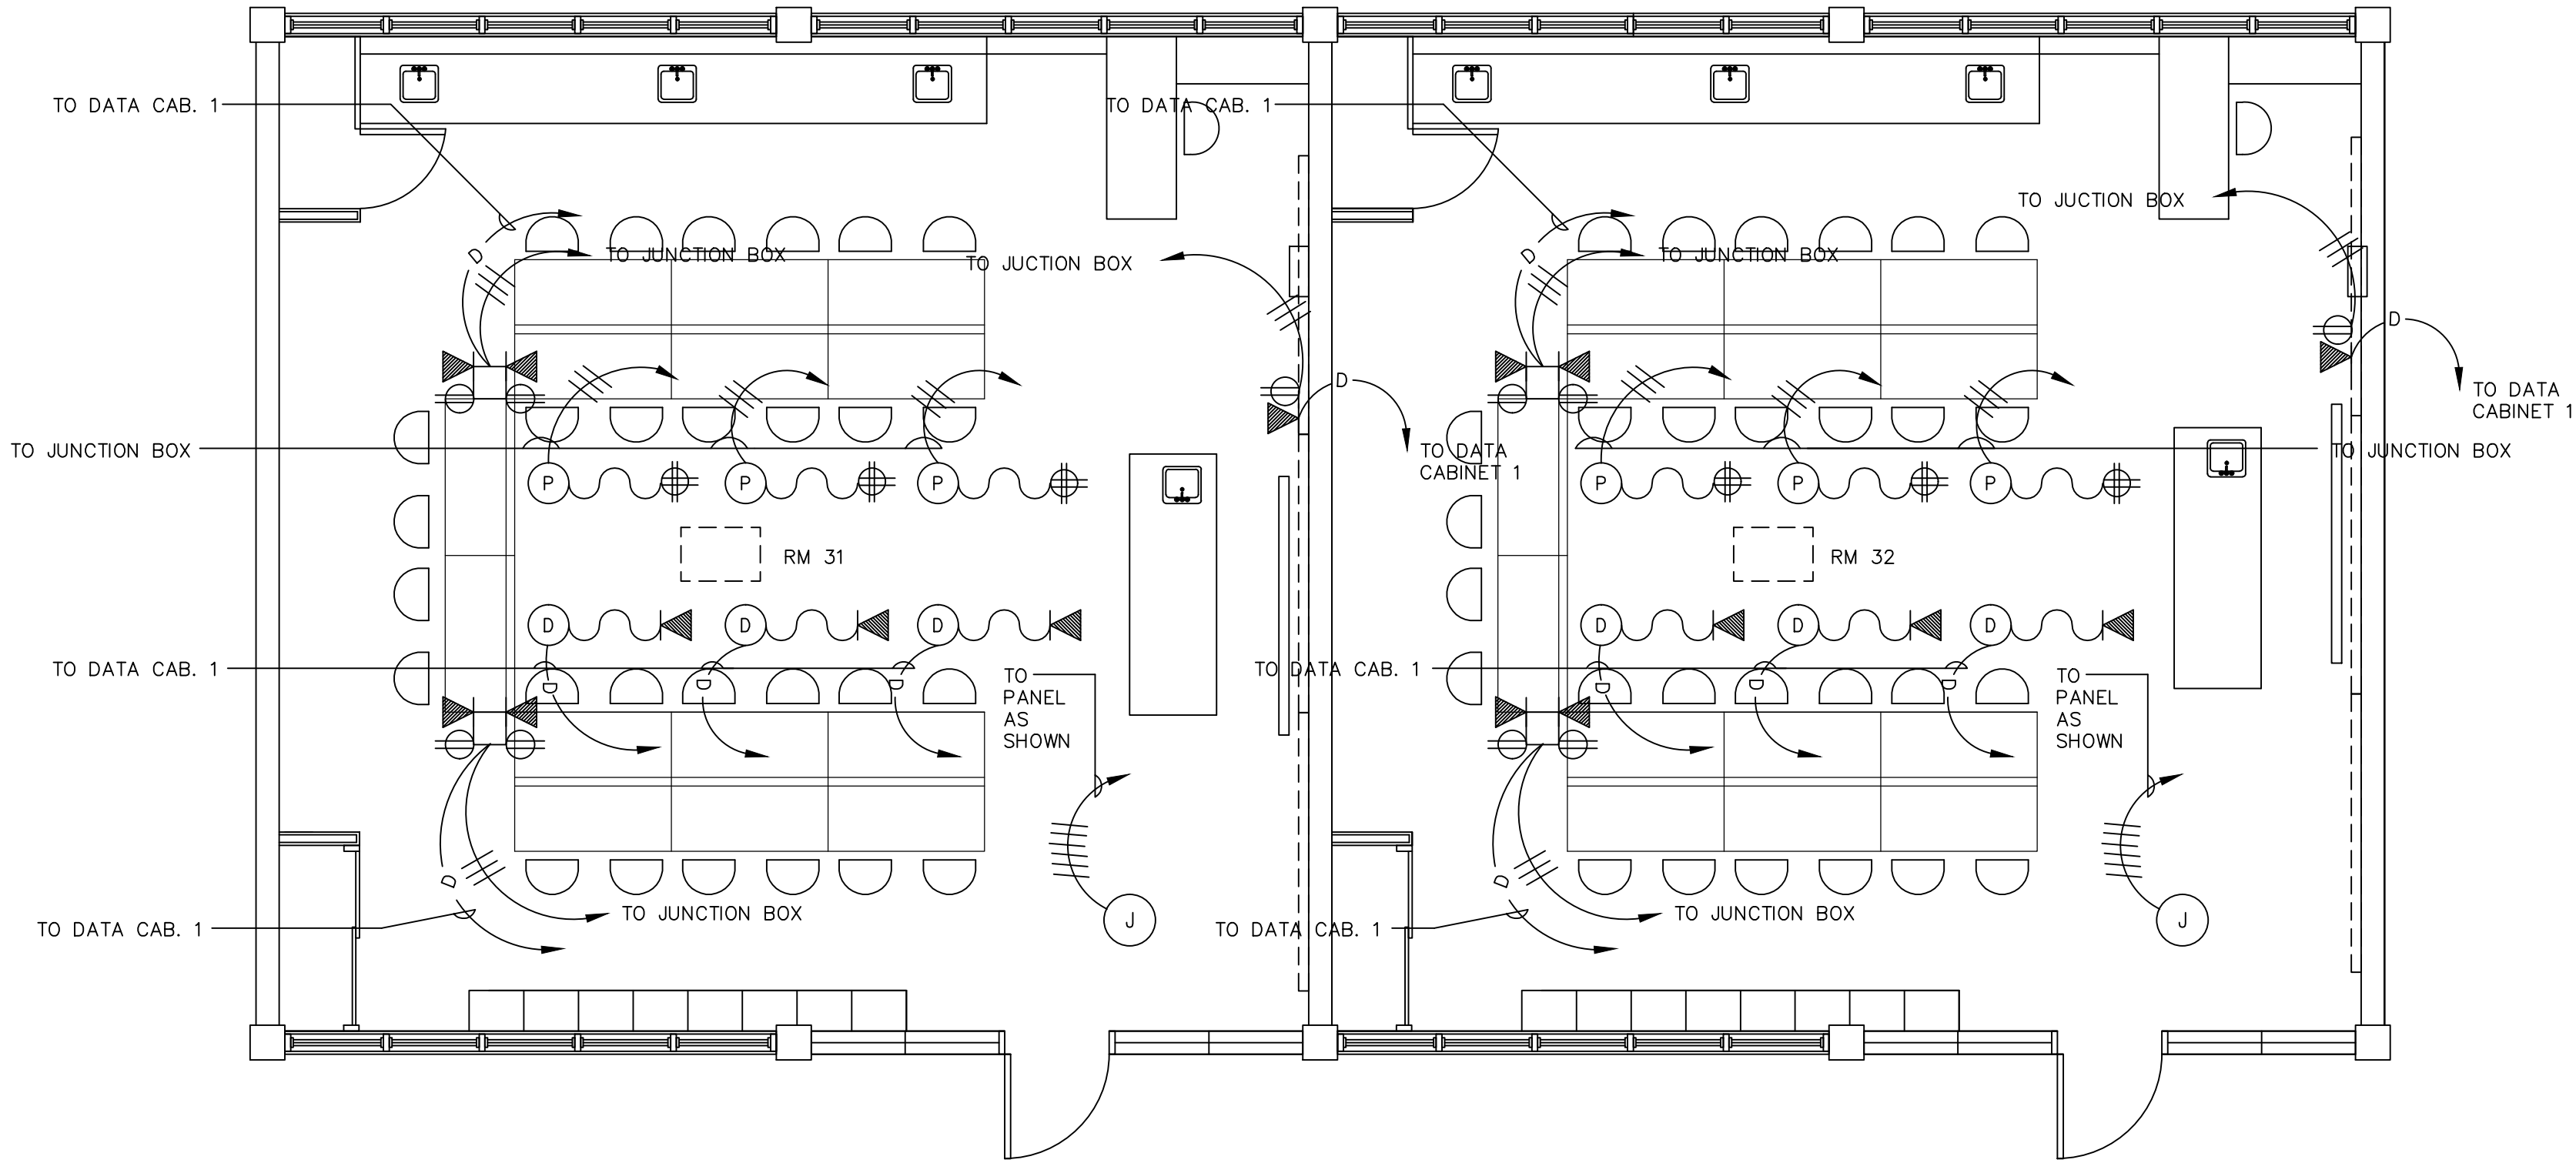

ROOM 31 TO 32 (SCIENCE)
TYPICAL CLASSROOM POWER/SIGNAL PLAN
E-4.1 SCALE: 1/4" = 1'-0"



AS-BUILT

DATE: _____
SIGNED: _____

PARTIAL FLOOR (RMS. 31-36) -
LIGHTING PLAN &
POWER/SIGNAL PLAN
NEW CONDITION

PROJECT TITLE:
STEM CLASSROOM RENOVATION
LUIS P. UNTALAN MIDDLE SCHOOL

Guam Department of Education
HAGATNA GUAM


REVISION	DESCRIPTION	DATE

DESIGNED BY: _____
DRAWN BY: _____
CHECKED BY: _____
ACAD FILE NO: _____
DATE: _____


SHEET NO:

E-4.0


— OF —

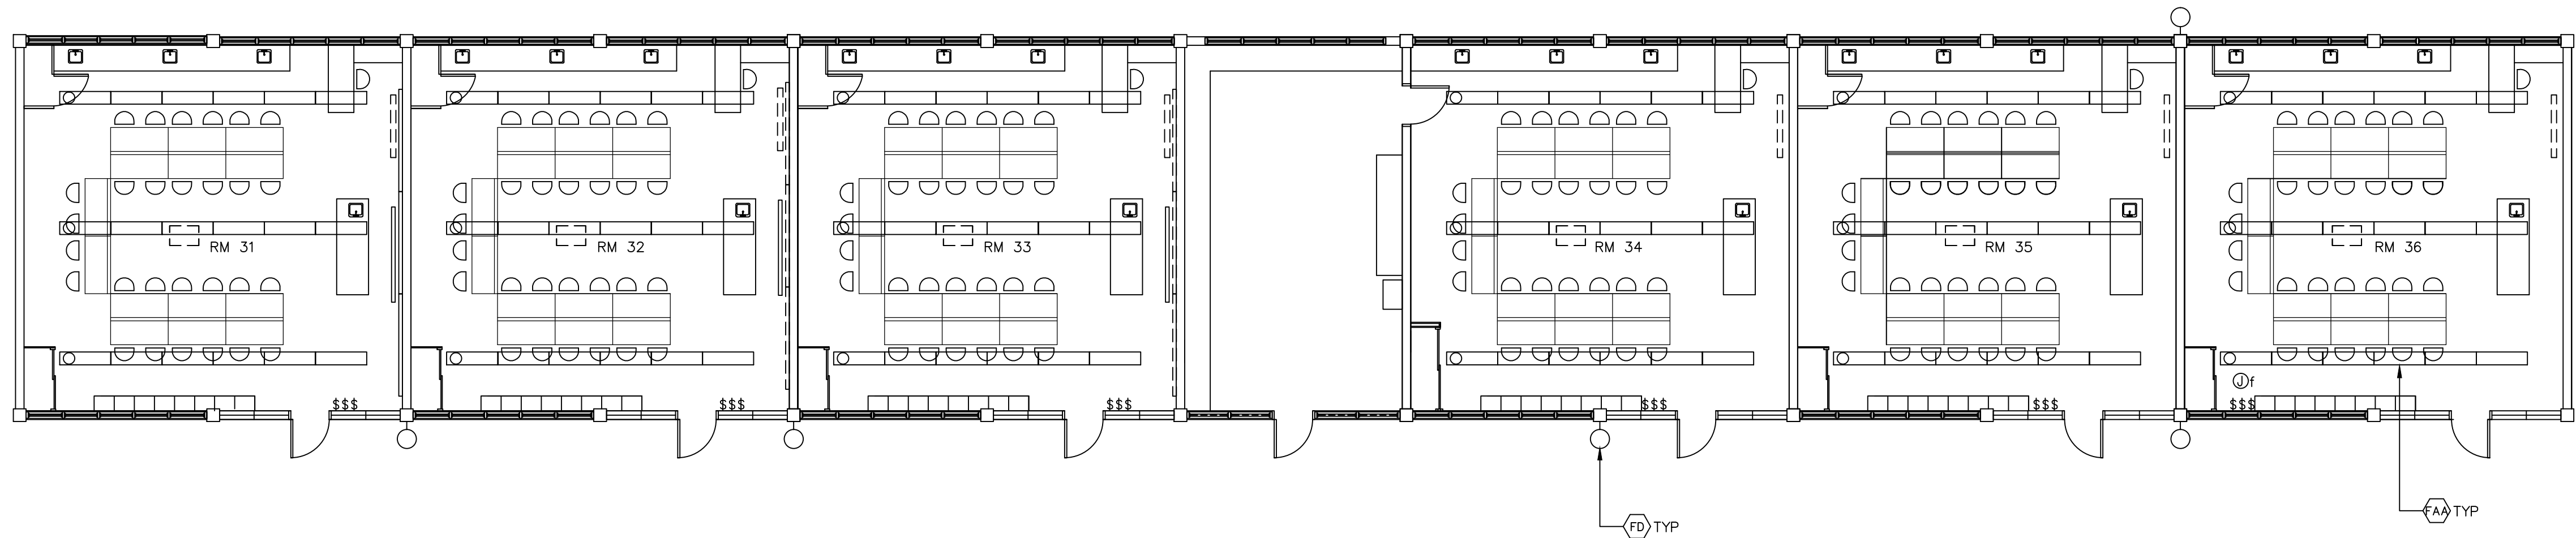

1 PARTIAL FLOOR (RMS. 31-36) - LIGHTING PLAN NEW CONDITION
E-4.0 SCALE: 1/8" = 1'-0"

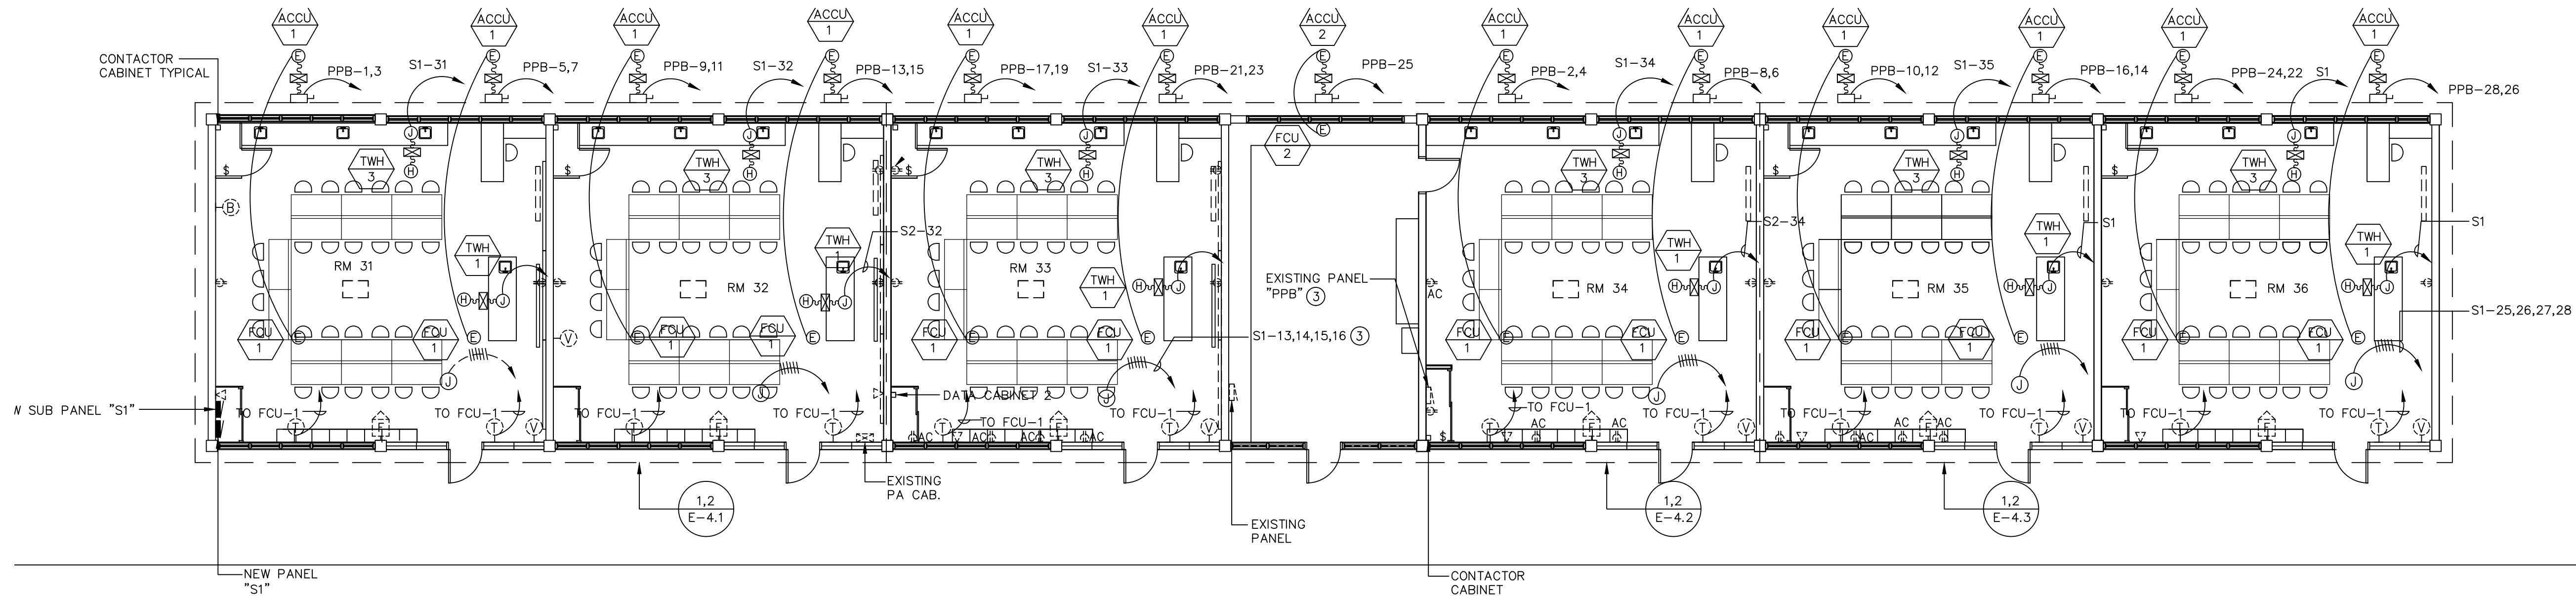

2 PARTIAL FLOOR (RMS. 31-36) - POWER/SIGNAL PLAN NEW CONDITION
E-4.0 SCALE: 1/8" = 1'-0"

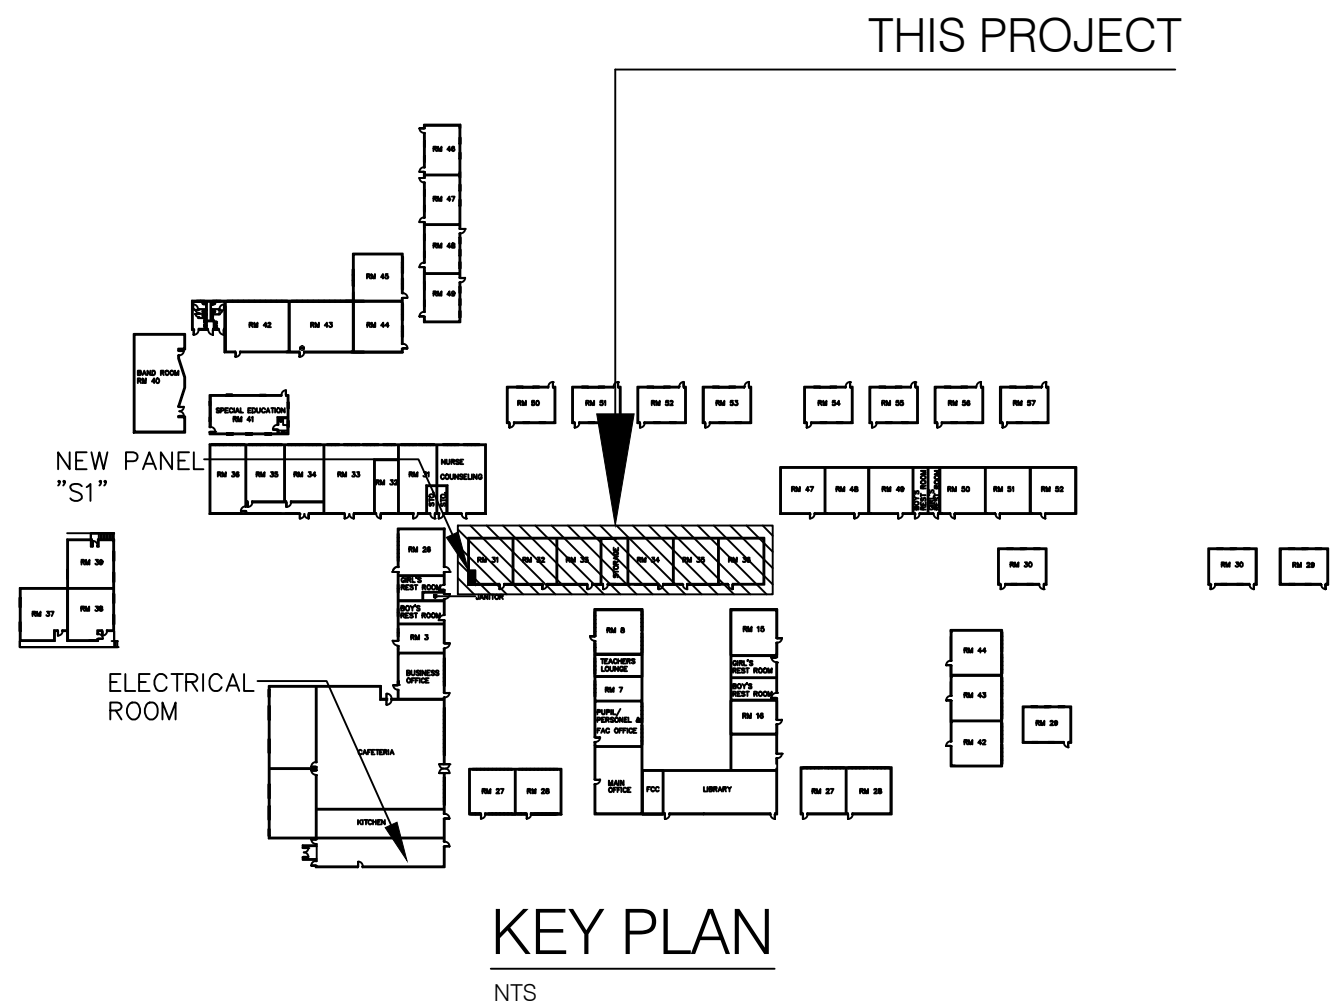

KEY PLAN
NTS



AS-BUILT

DATE: _____
SIGNED: _____

RMS: 50-52 (TECHNOLOGY)
TYPICAL CLASSROOM
POWER/SIGNAL PLAN

PROJECT TITLE:
STEM CLASSROOM RENOVATION
LUIS P. UNTALAN MIDDLE SCHOOL

Guam Department of Education
HAGATNA GUAM


REVISION	DESCRIPTION	DATE

DESIGNED BY: _____
DRAWN BY: _____
CHECKED BY: _____
ACAD FILE NO: _____
DATE: _____


SHEET NO:

E-3.2



— OF —

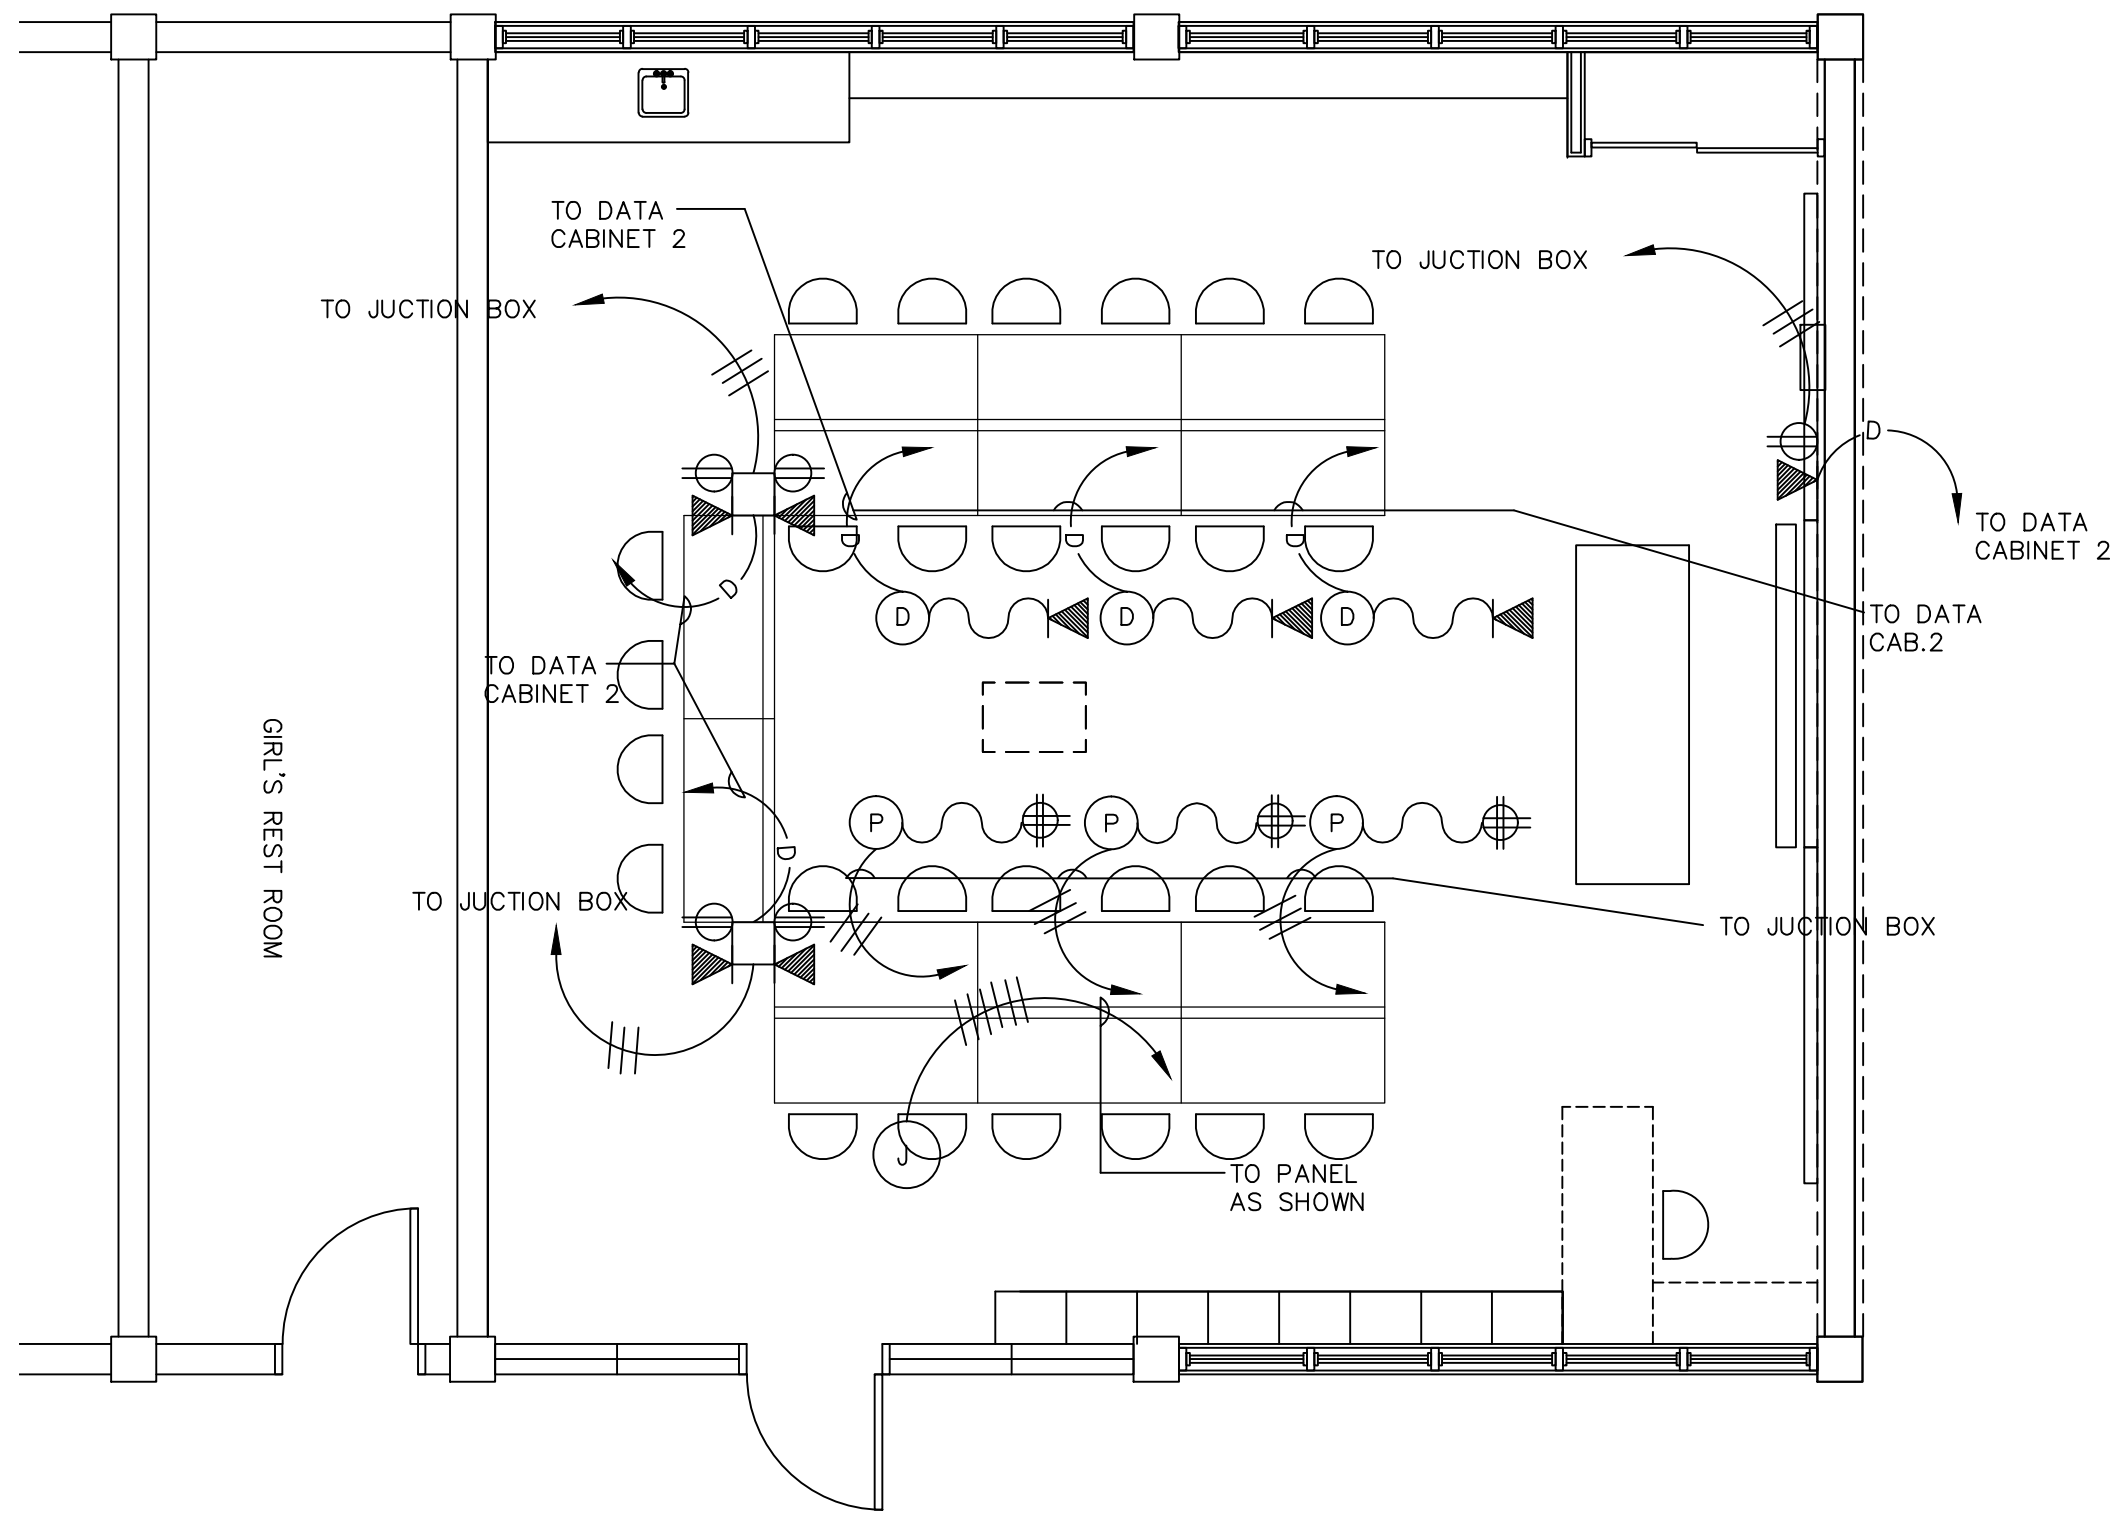

1 ROOM 50 (TECHNOLOGY)
E-3.2 POWER/SIGNAL PLAN
SCALE: 1/8" = 1'-0"

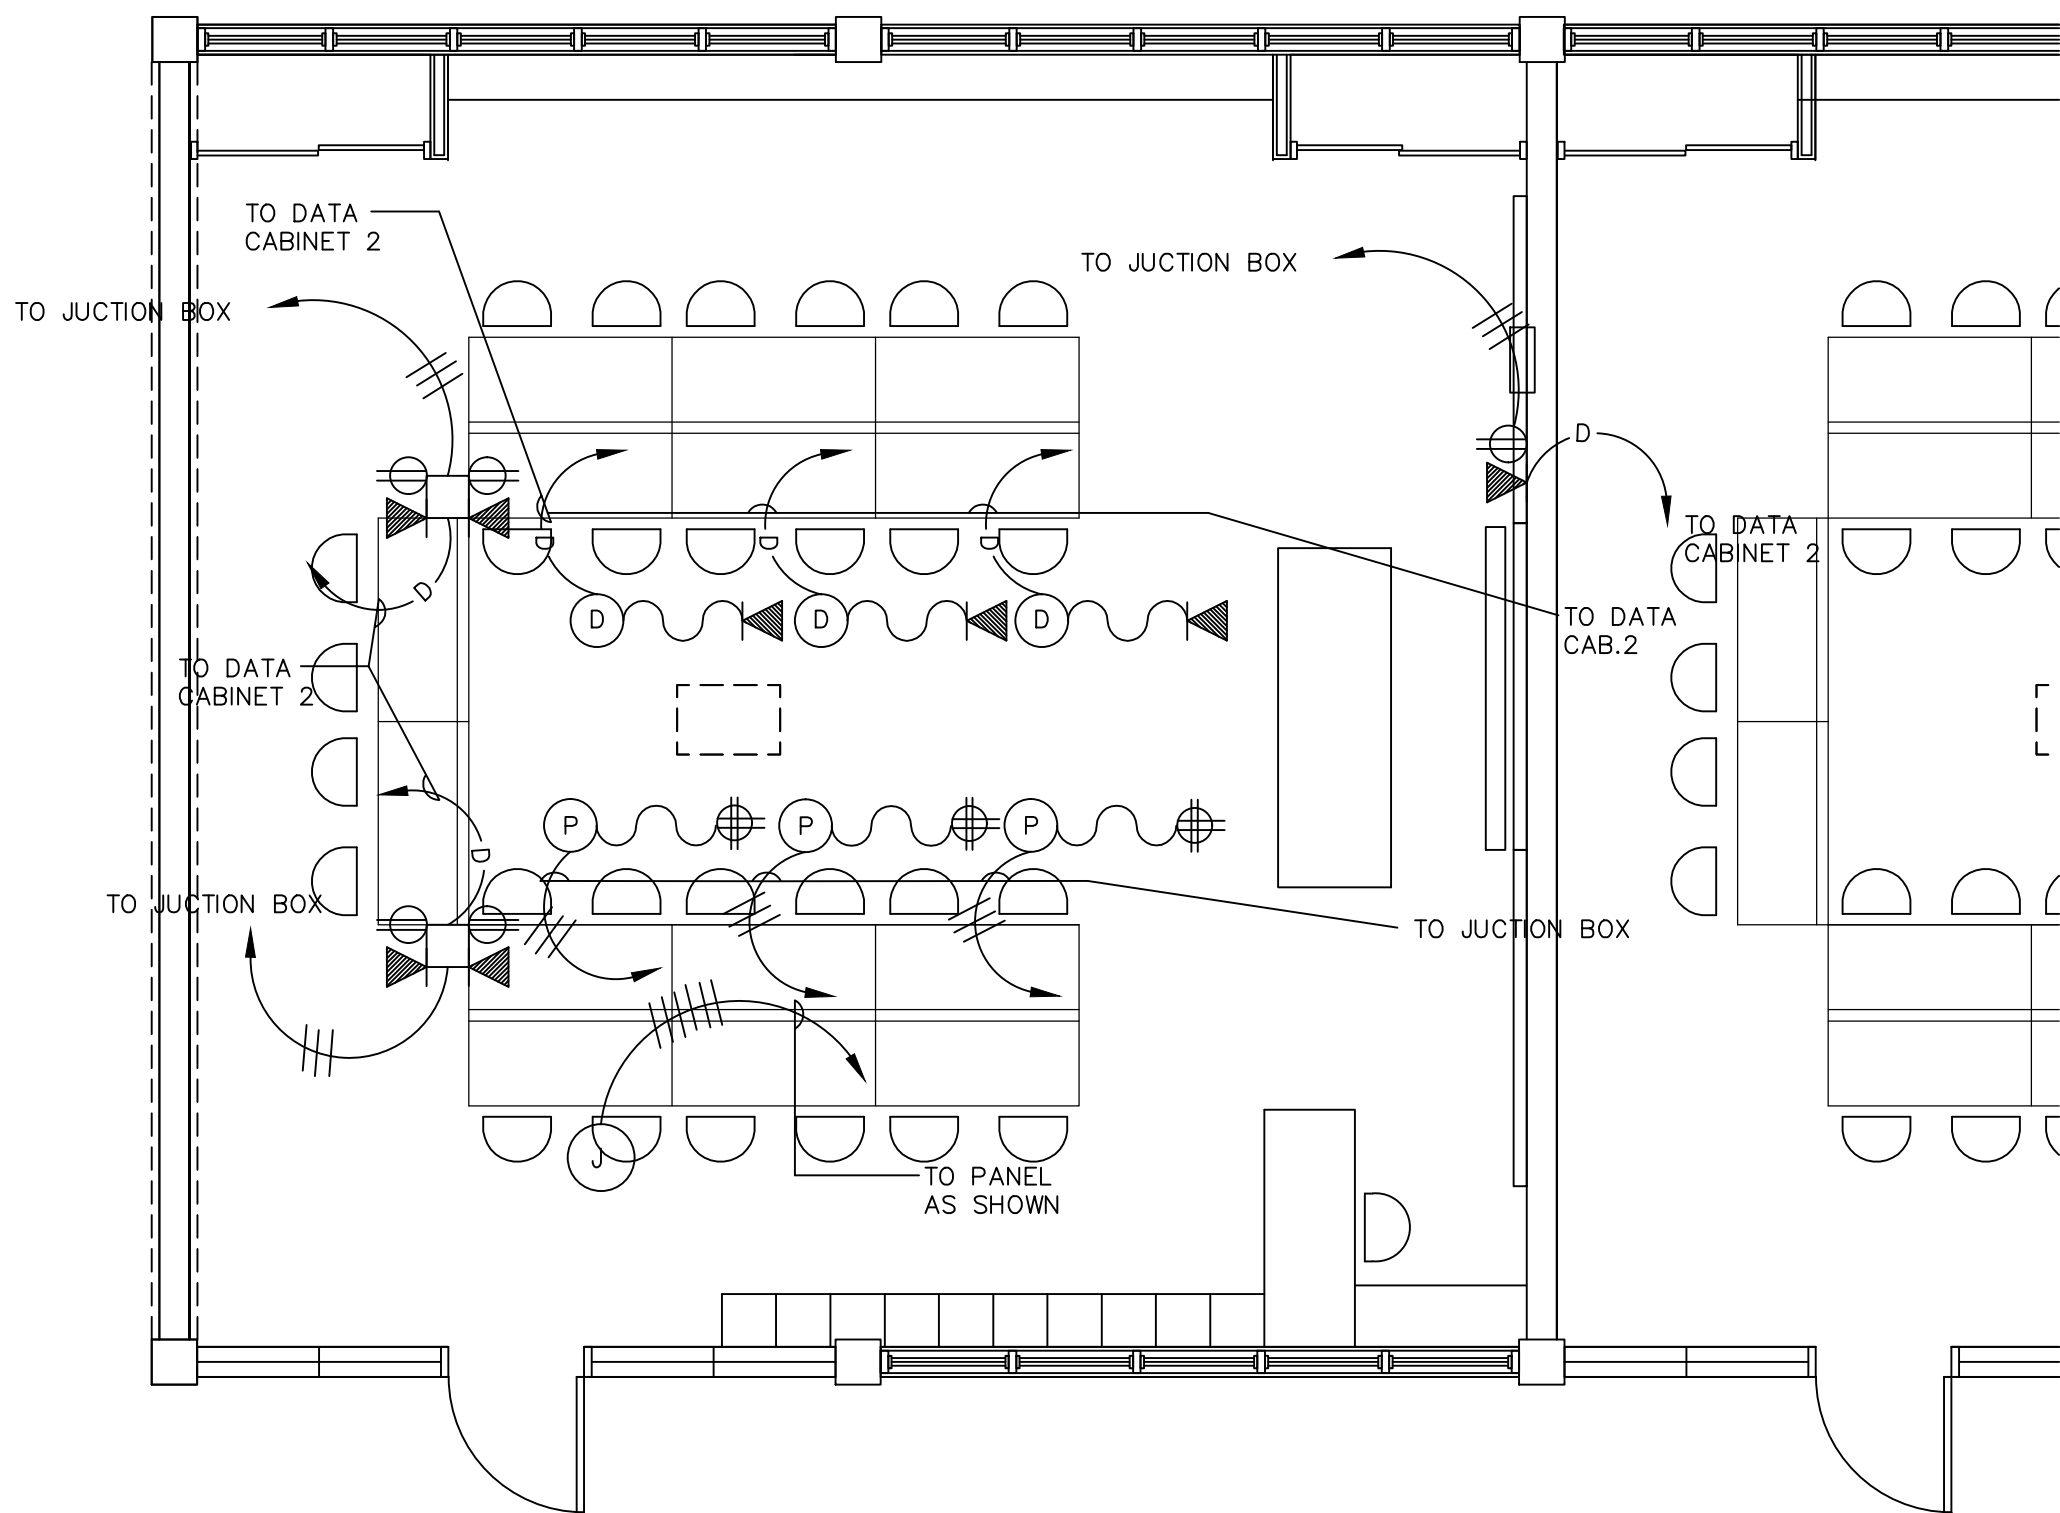

2 ROOMS 51 & 52 (TECHNOLOGY)
E-3.2 TYPICAL CLASSROOM-POWER/SIGNAL PLAN
SCALE: 1/8" = 1'-0"

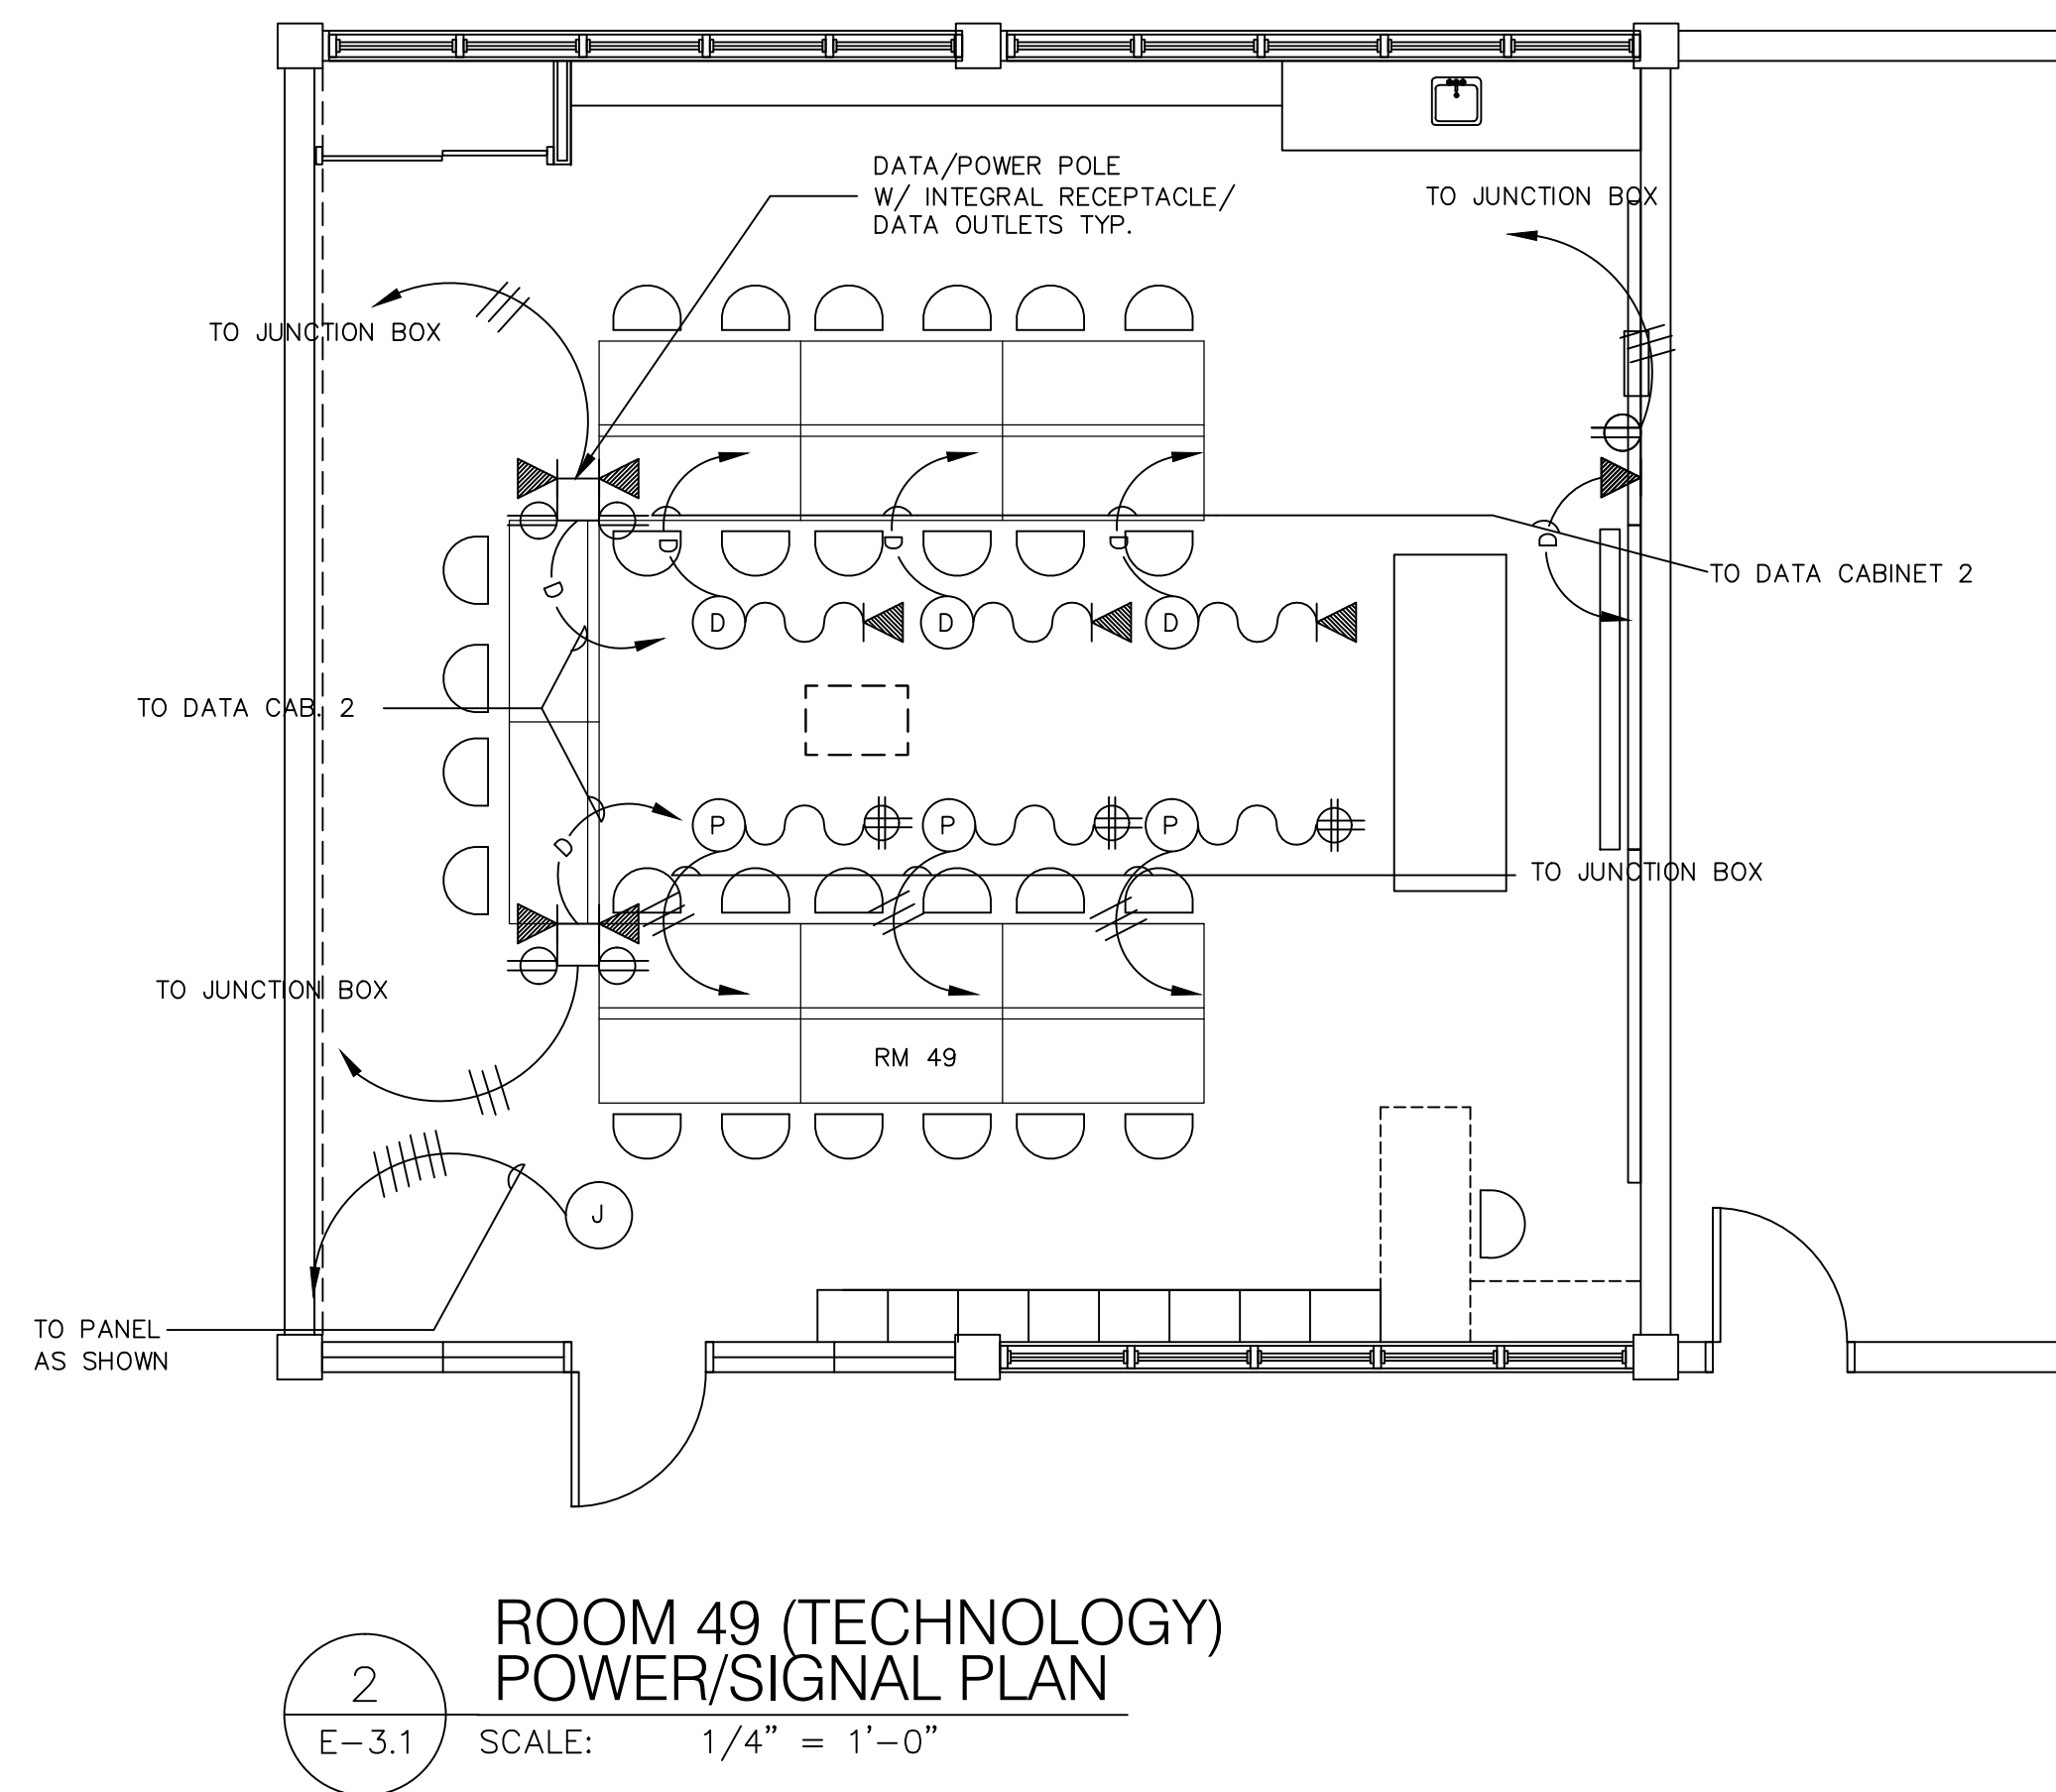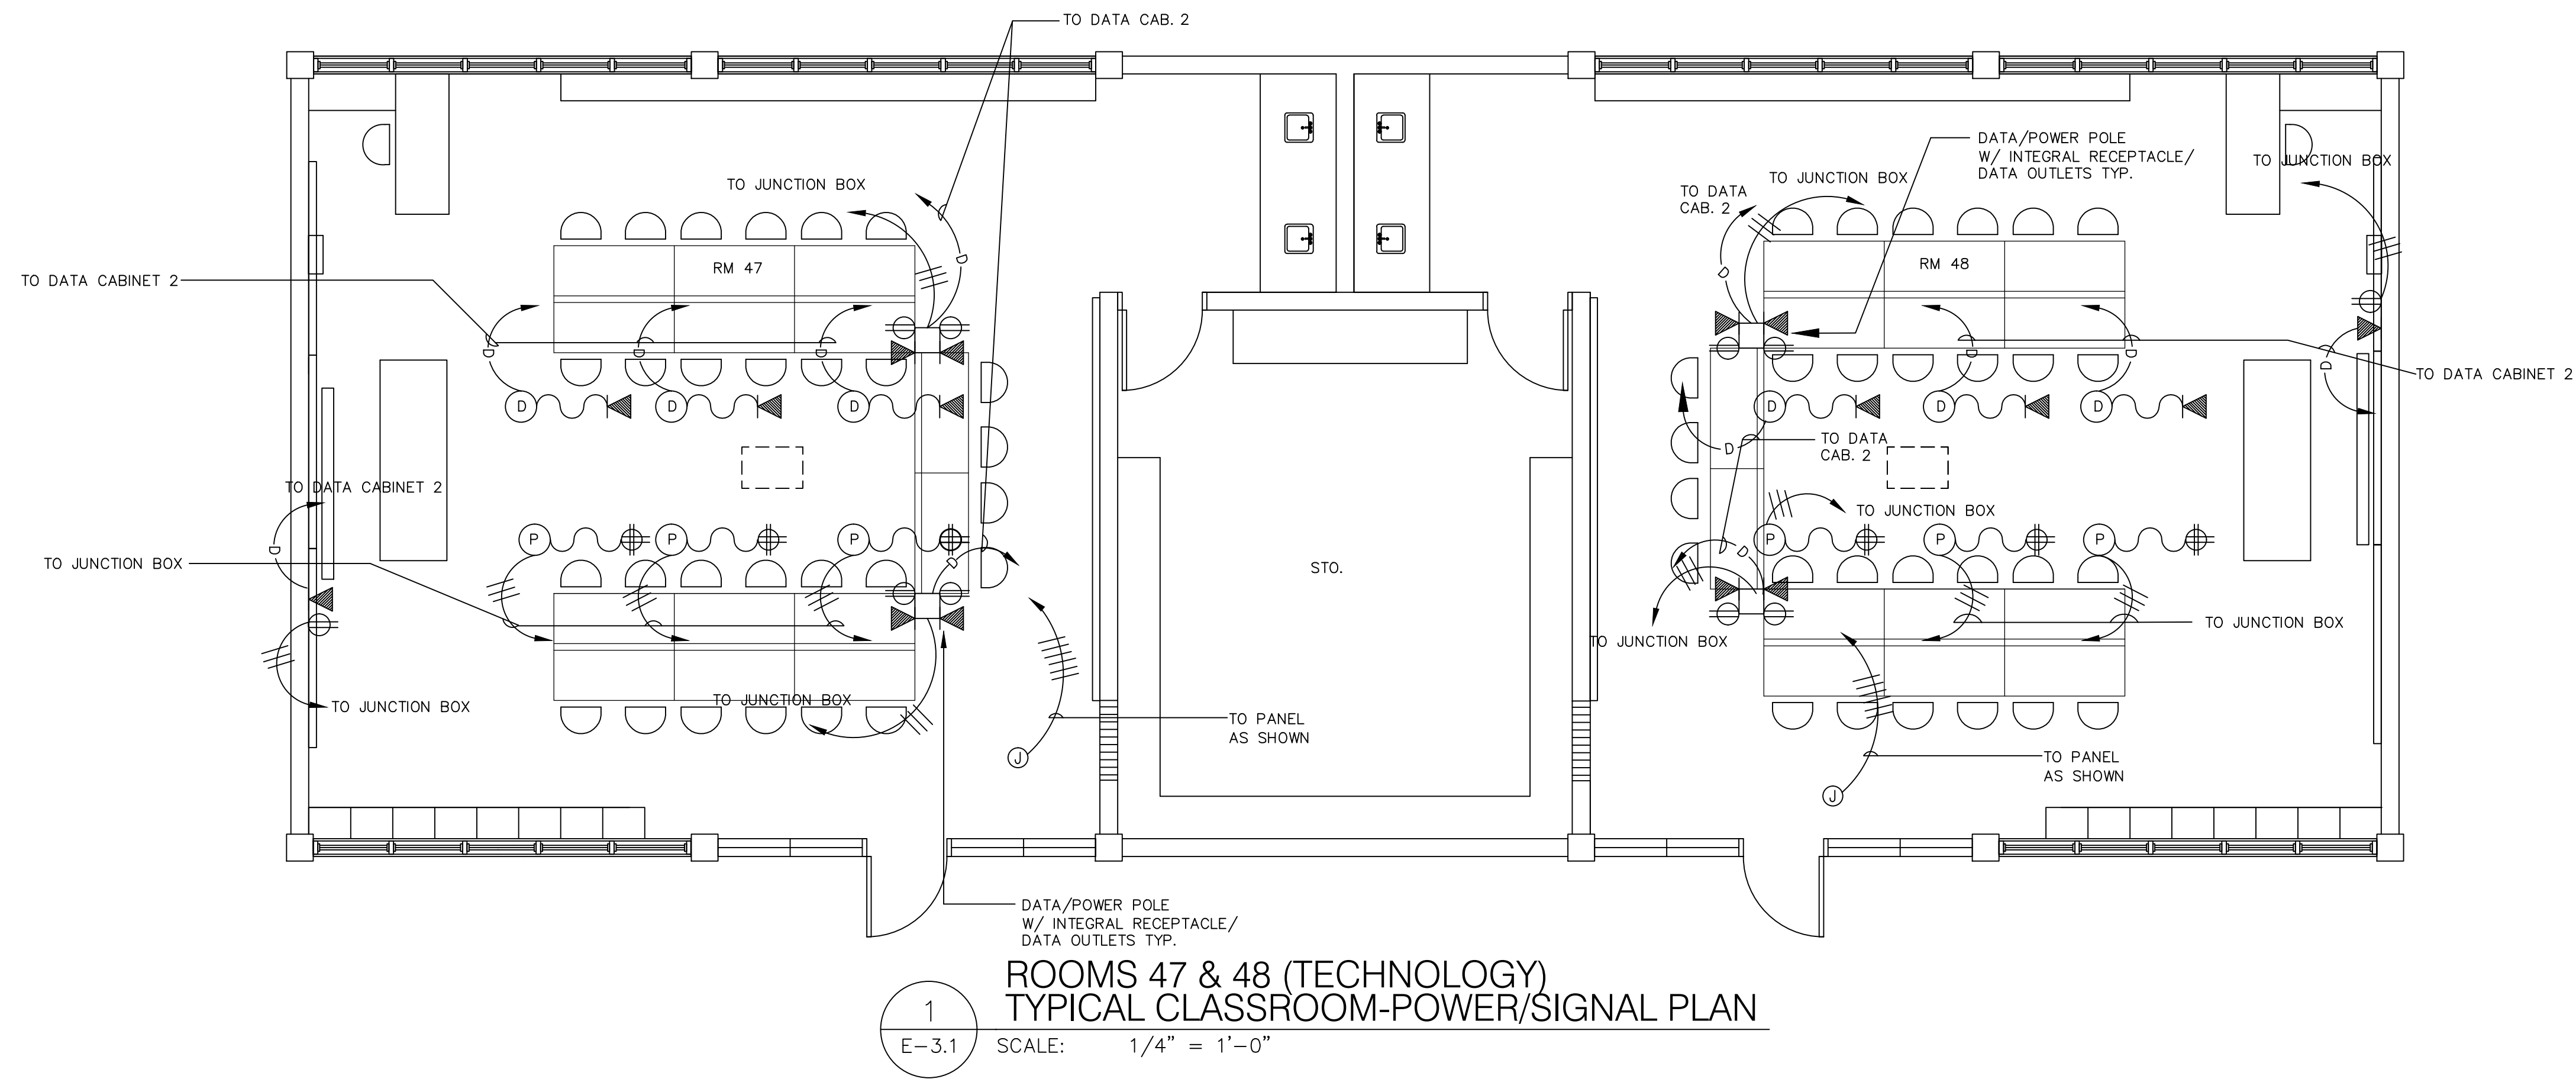

AS-BUILT

DATE:

SIGNED:

SHEET TITLE:

RMS. 47-49 (TECHNOLOGY)
TYPICAL CLASSROOM
POWER/SIGNAL PLAN

PROJECT TITLE:

STEM CLASSROOM RENOVATION
LUIS P. UNTALAN MIDDLE SCHOOL

Guam Department of Education
HAGATNA GUAM

DATE

DESCRIPTION

REVISION

DESIGNED BY:

DRAWN BY:

CHECKED BY:

ACAD FILE NO:

DATE:

SHEET NO:

E-3.1

— OF —



AS-BUILT

DATE: _____
SIGNED: _____

PARTIAL FLOOR (RMS. 47-52) -
LIGHTING PLAN &
POWER/SIGNAL PLAN
NEW CONDITION

STEM CLASSROOM RENOVATION
LUIS P. UNTALAN MIDDLE SCHOOL

Guam Department of Education
HAGATNA GUAM


REVISION	DESCRIPTION	DATE

DESIGNED BY: _____
DRAWN BY: _____
CHECKED BY: _____
ACAD FILE NO: _____
DATE: _____


SHEET NO:

E-3.0

— OF —

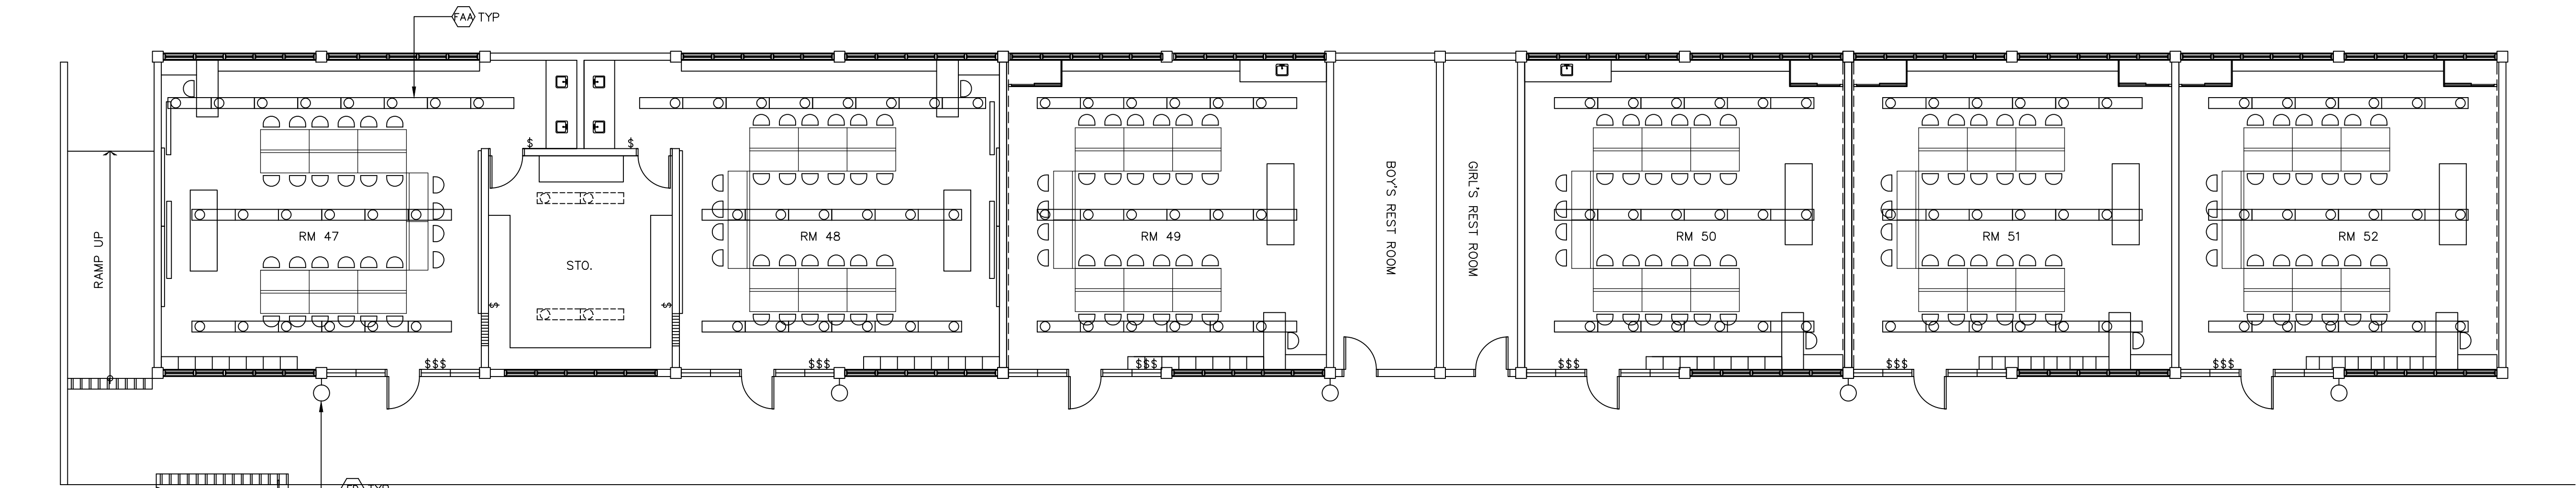

1 PARTIAL FLOOR (RMS. 47-52) - LIGHTING PLAN NEW CONDITION
E-3.1 SCALE: 1/8" = 1'-0"

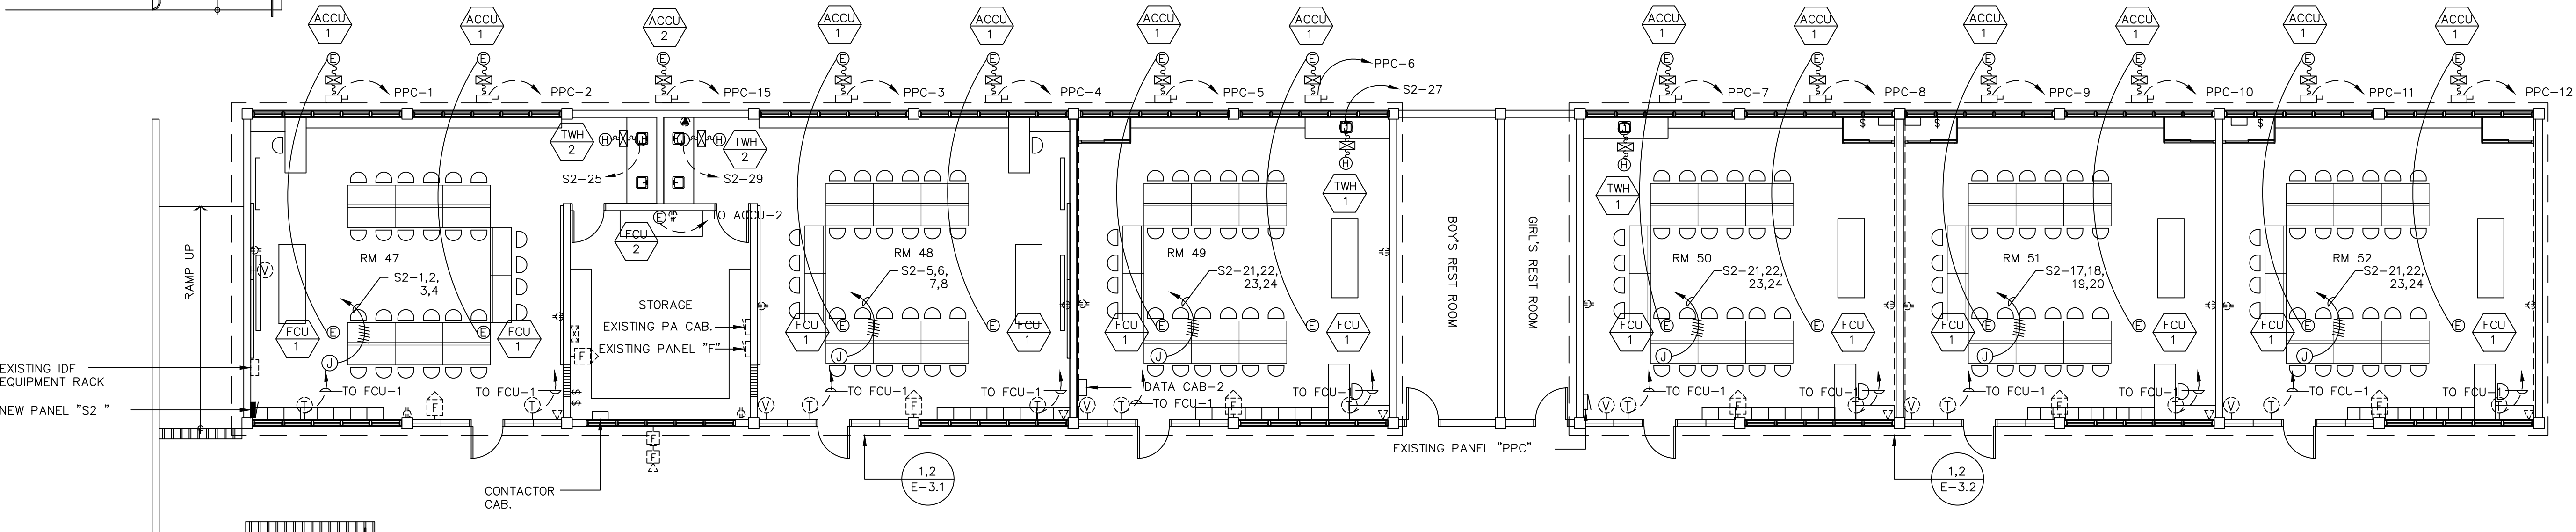

2 PARTIAL FLOOR (RMS. 47-52) - POWER/SIGNAL PLAN NEW CONDITION
E-3.1 SCALE: 1/8" = 1'-0"

